


DRAWING LIST

- 00 COVER SHEET
- A00 SITE PLAN
- A01 PLANS
- A02 PROPOSED ROOF PLAN
- A03 PROPOSED ROOF FRAMING PLANS
- A04 SECTION
- A05 DETAIL - TRUSS& SCHEDULES
- A06 DETAIL - FOUNDATIONS
- A07 DETAIL - TIMBER FRAME
- A08 3D MODEL
- A09 CONSTRUCTION SPEC'S

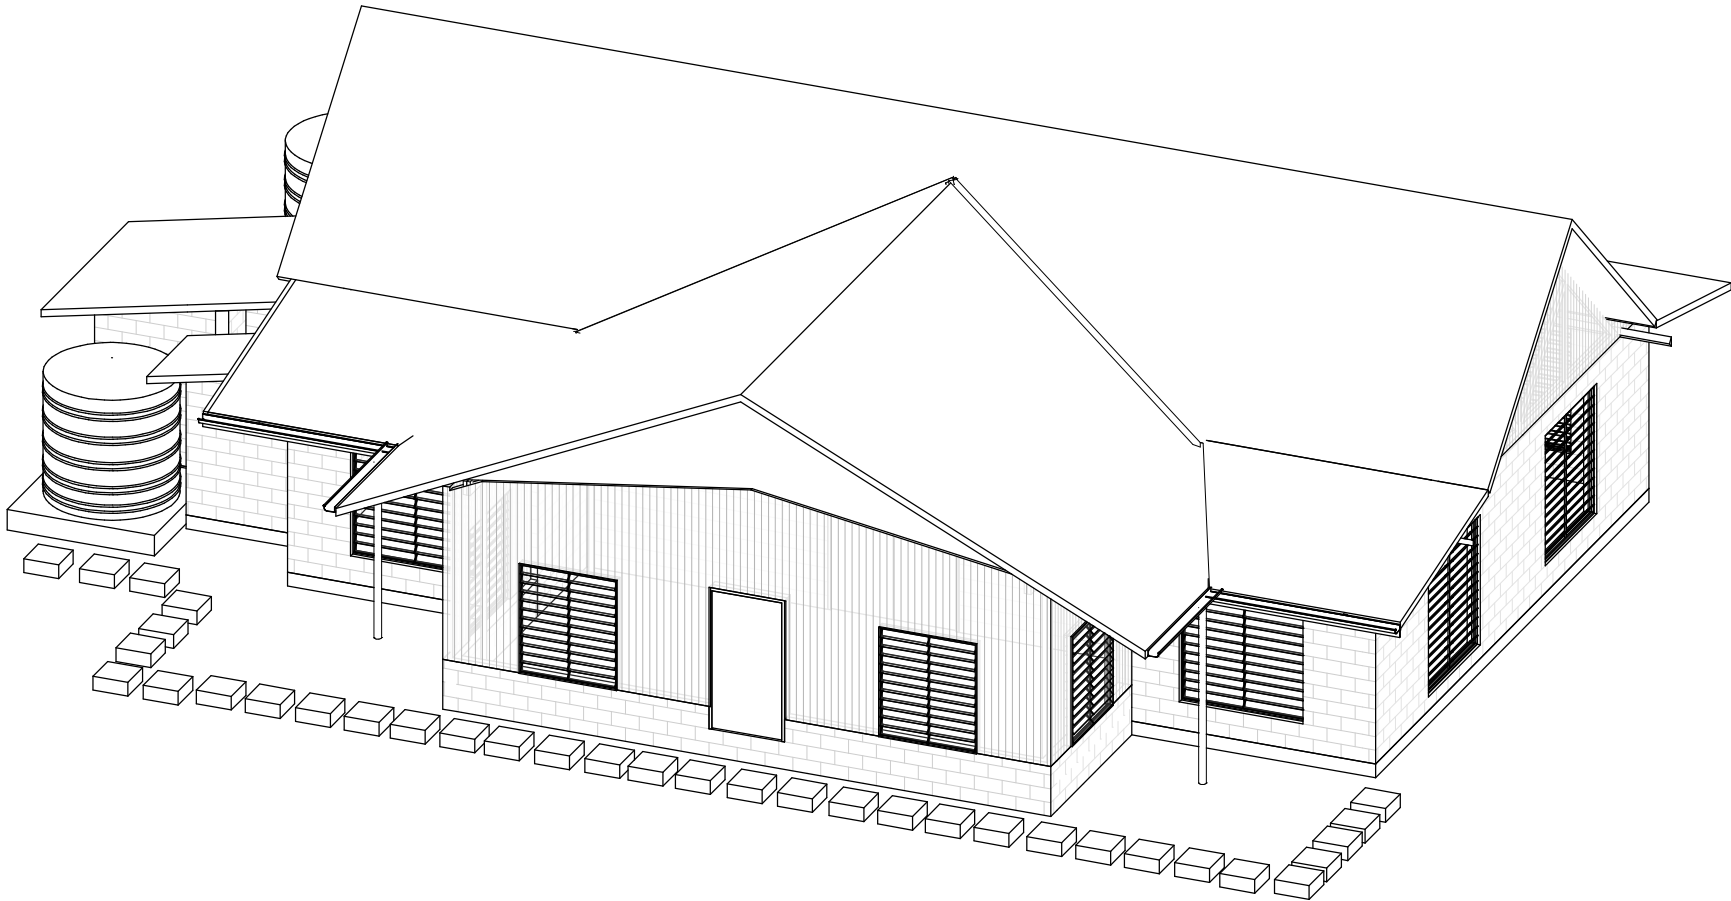

1 LAGOOND VIEW
Scale:

142102

HM RESIDENCE VERANDAH

MFMRD

MISE ARCHITECTURAL UNIT

TDS

TECHNICAL DESIGN SECTION
MINISTRY OF
INFRASTRUCTURE&SUSTAINABLE ENERGY
PO BOX 498
BETIO, TARAWA
REPUBLIC OF KIRIBATI
CENTRAL PACIFIC
PHONE: +686 26192
HM Residence Verandah


CLIENT: MFMRD
PROJECT NO: 142102

DWG TITLE:
COVER SHEET

DRAWN BY: KB
REVIEWED BY:BR
DATE: 220413
SCALE:

DRAWING NUMBER: 00
ISSUE: 02

13/04/2022 3:25:50 PM
O:\DESIGN\1.2 Current Projects\142102 MFMRD HM Residence Verandah\06 Drawings\0602 Building 1142102 MFMRD HM Residence Verandah_Revise.dwg
Verandah_Revise.dwg 220412 FOR CPU.rvt

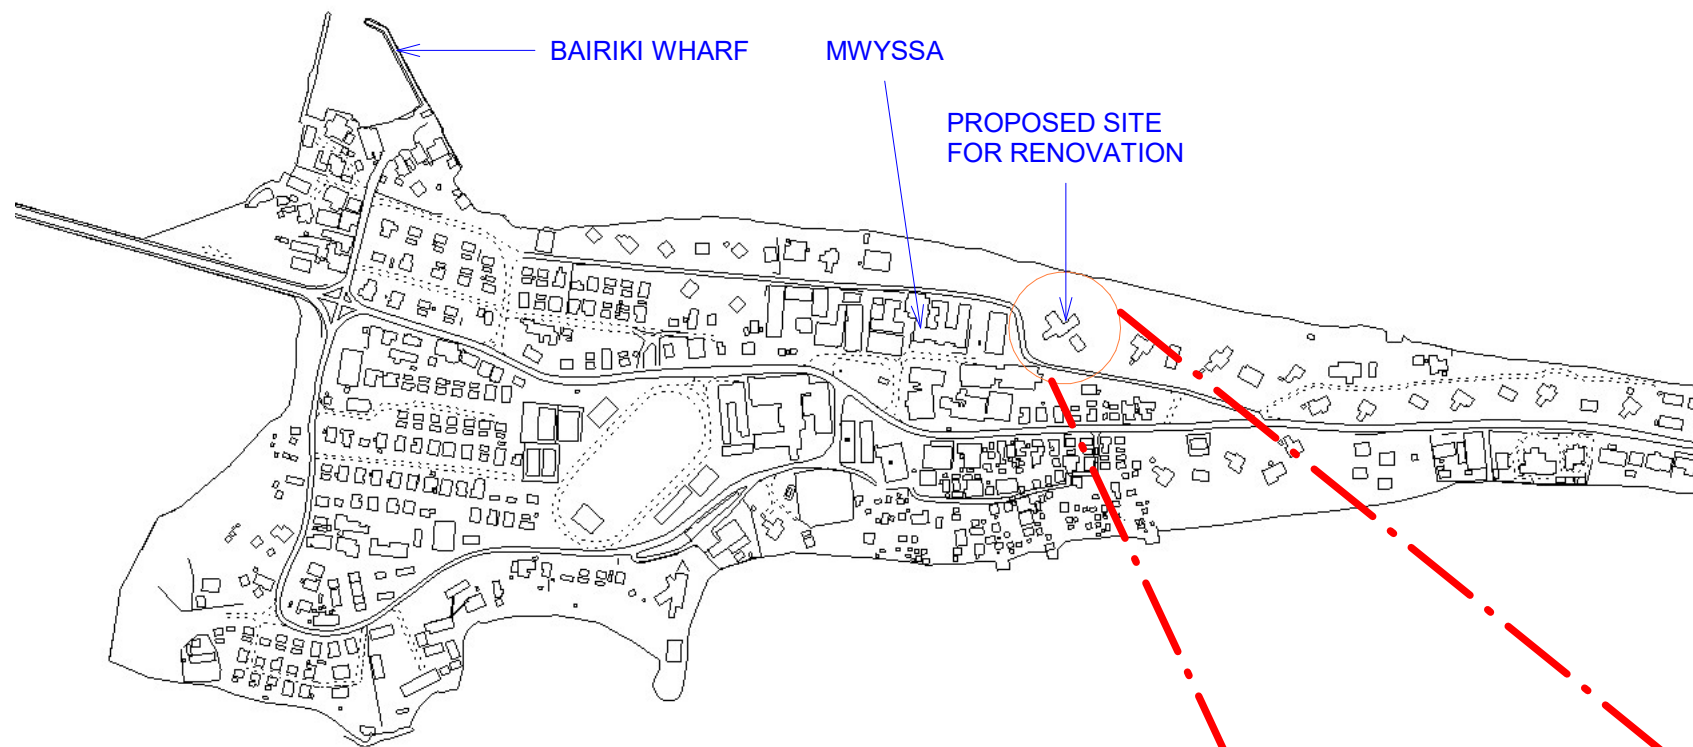

1 LOCALITY-BAIRIKI

Scal 1 : 5000
e:

SCOPE OF WORK


- REMOVE THE WHOLE VERANDAH SAFELY
- INSTALL THE NEW VERANDAH ACCORDING TO DESIGN
- INSTALL THE VYNIL TILE

3 SCOPE OF WORK

Scal 1 : 100
e:

2 SITE PLAN

Scal 1 : 500
e:

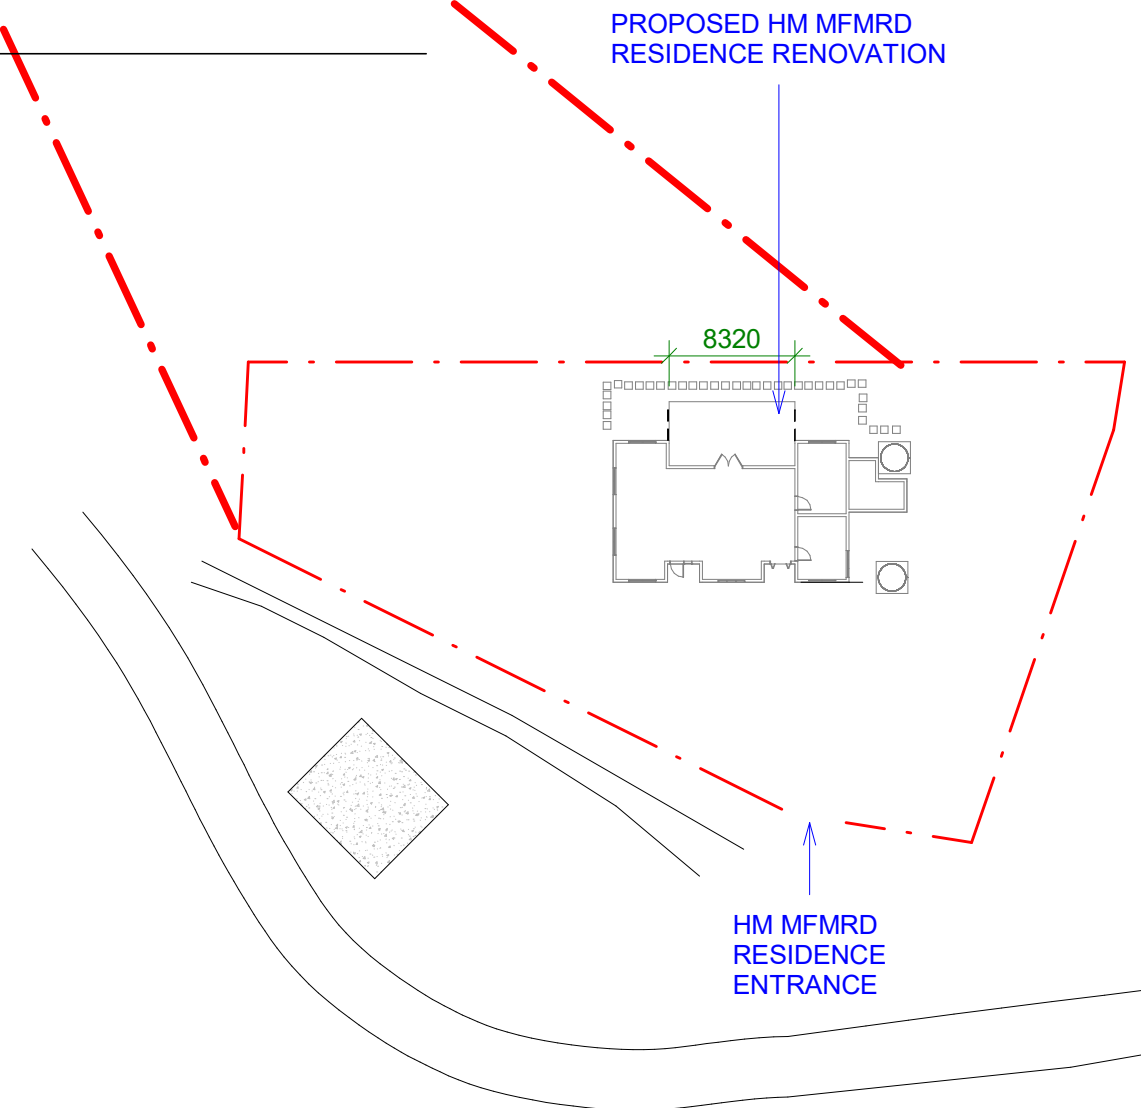

TDS
TECHNICAL DESIGN SECTION
MINISTRY OF
INFRASTRUCTURE&SUSTAINABLE ENERGY
PO BOX 498
BETIO, TARAWA
REPUBLIC OF KIRIBATI
CENTRAL PACIFIC
PHONE: +686 26192
HM Residence Verandah

CLIENT: MFMRD
PROJECT NO: 142102


DWG TITLE:
SITE PLAN

DRAWN BY: KB
REVIEWED BY: BR
DATE: 220413
SCALE: As indicated

DRAWING NUMBER: ISSUE:


A00

02

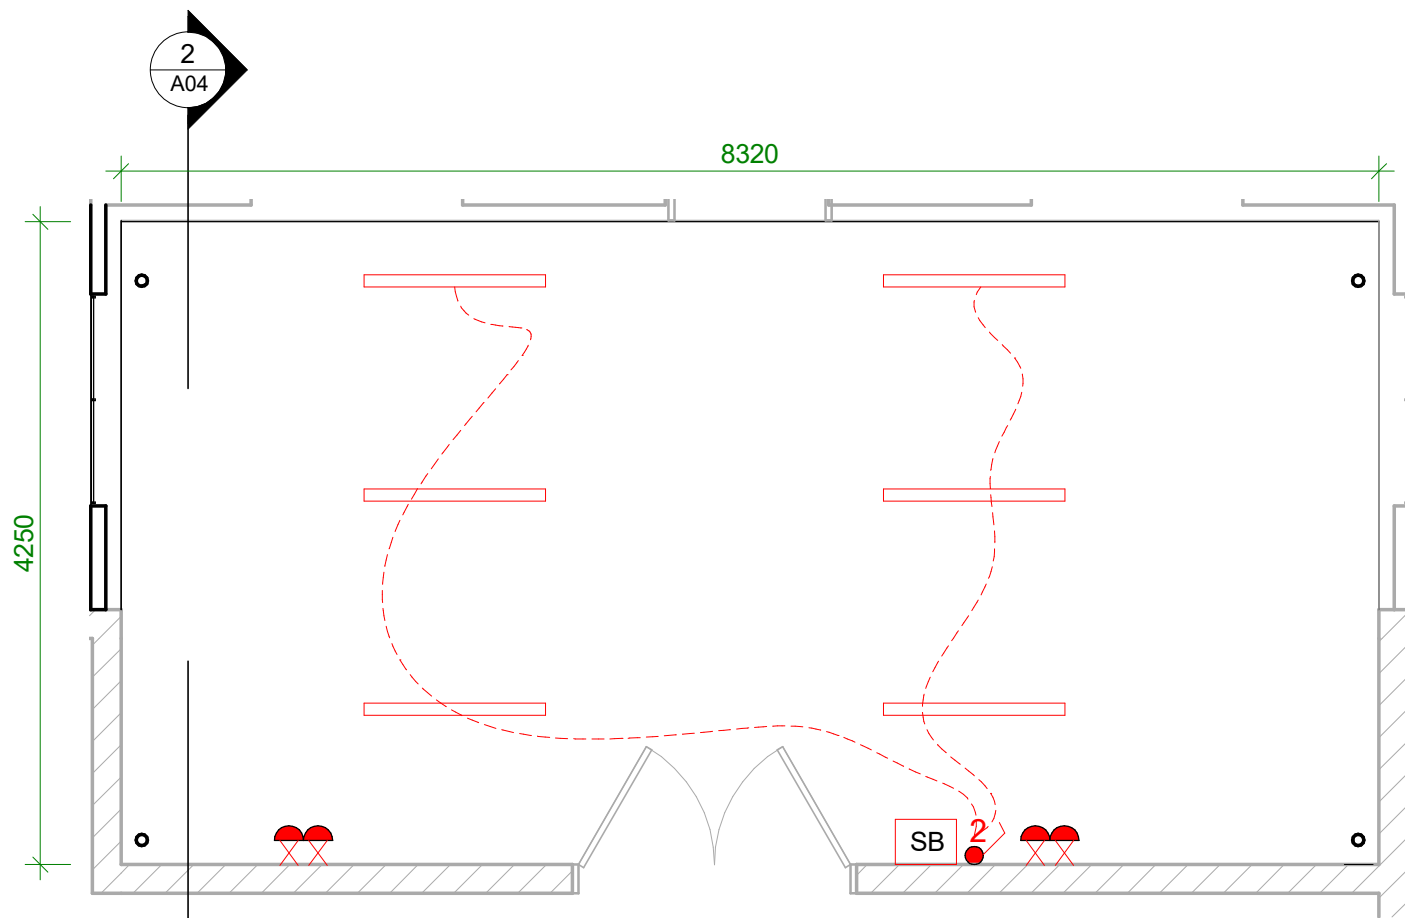


PROPOSED LAYOUT & ELECTRICAL PLAN

4
Scal 1 : 50
e:

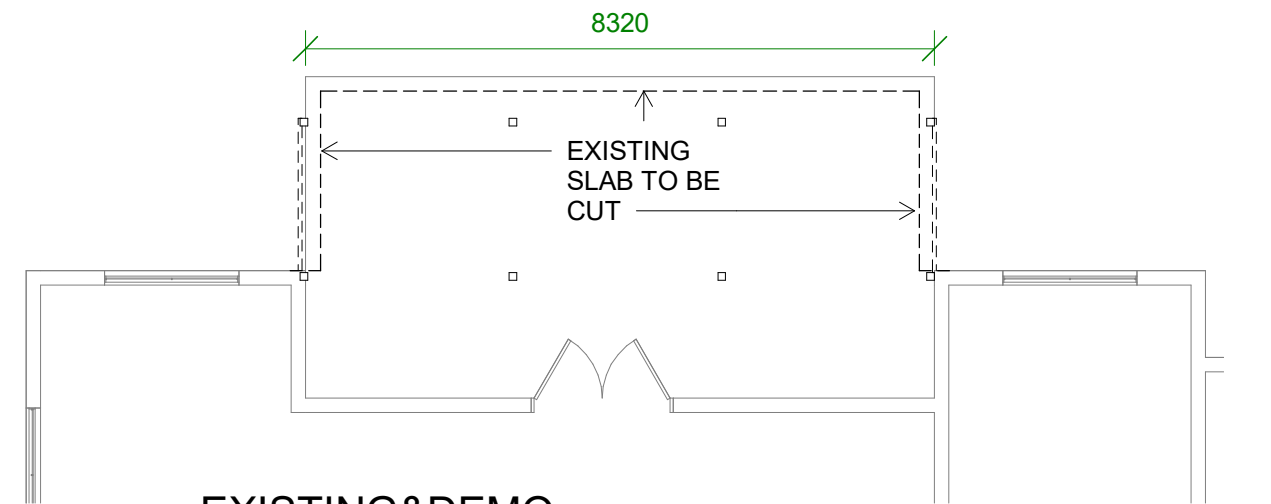

EXISTING & DEMO PLAN-PORION


2
Scal 1 : 100
e:

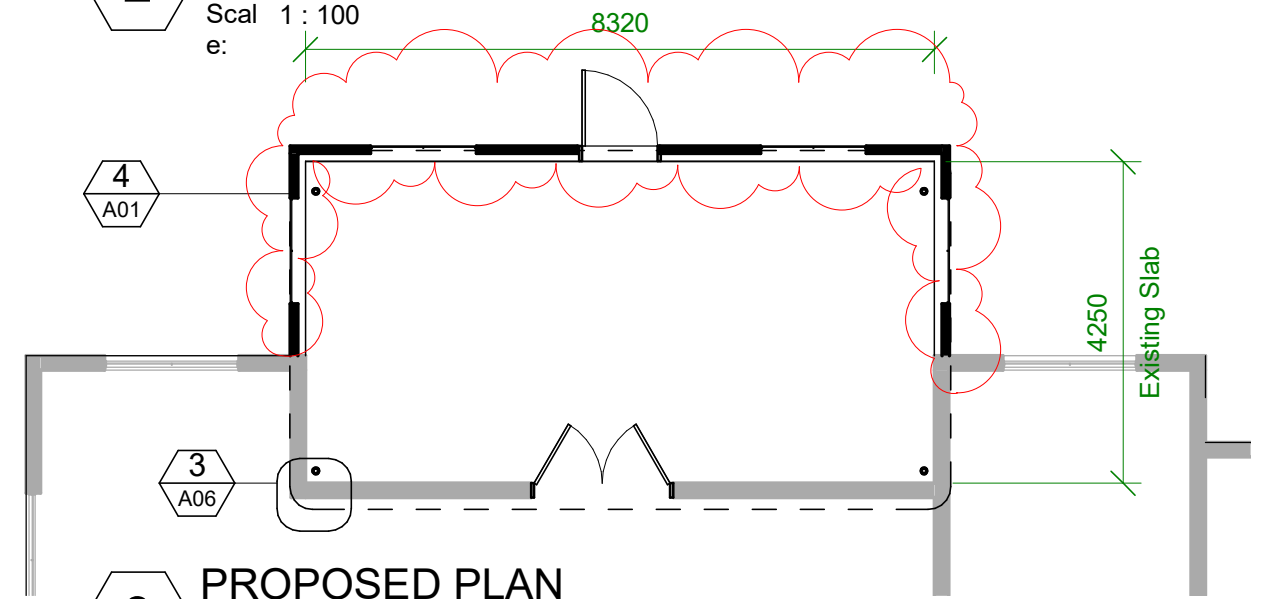

PROPOSED PLAN

3
Scal 1 : 100
e:

1 Additional Verandah Wall 22/04/12

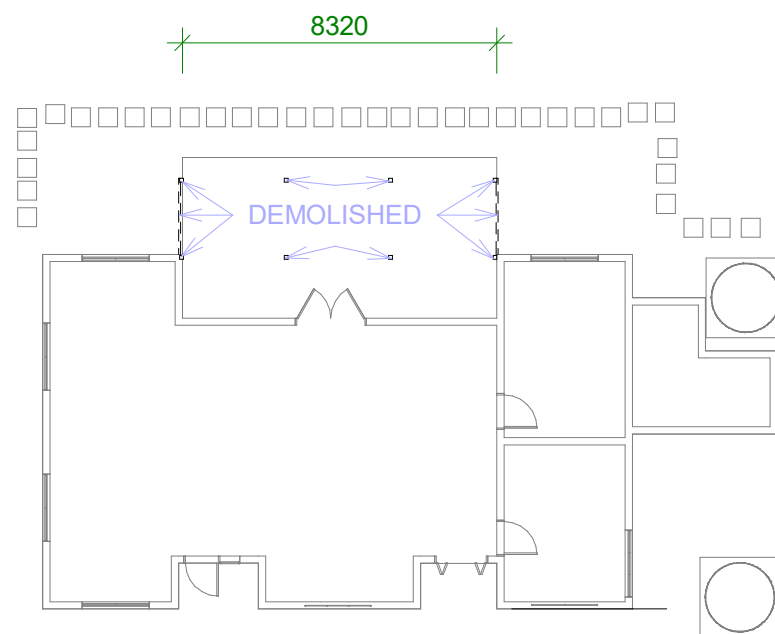

EXISTING & DEMO PLAN-OVERALL

1
Scal 1 : 200
e:

ELECTRICAL LEGEND

- sb - SWITCHBOARD
- GPO MOUNTED ABOVE BENCH LEVEL
- SWITCH POINT
- 2 - 2 WAYS SWITCH
- 1200 LONG FLUORESCENT BATTEN
- CABLE WIRE

NOTE:

- WHERE APPLICABLE, USE ENERGY EFFICIENT APPLIANCES
- CABLE WIRE SIZES SHOULD BE:
 - 4 OR 6 sqmm FOR UNDERGROUND CABLES FROM PUB BOX TO HOUSEHOLD SWITCHBOARD
 - 2.5 sqmm CABLES CONNECTING SWITCH-BOARD TO GPOS
 - 2.5 sqmm CABLES CONNECTING SWITCH-BOARD TO SWITCH POINTS
 - 1.5 sqmm CABLES CONNECTING SWITCH-POINTS TO LIGHTS AND OTHER CEILING/WALL MOUNTED APPLIANCES

ELECTRICAL ITEMS

5
Scal 1 : 100
e:

TDS

TECHNICAL DESIGN SECTION
MINISTRY OF
INFRASTRUCTURE & SUSTAINABLE ENERGY
PO BOX 498
BETIO, TARAWA
REPUBLIC OF KIRIBATI
CENTRAL PACIFIC
PHONE: +686 26192

HM Residence Verandah


CLIENT: MFMRD
PROJECT NO: 142102

DWG TITLE:
PLANS

DRAWN BY: KB
REVIEWED BY: BR
DATE: 220413
SCALE: As indicated

DRAWING NUMBER: ISSUE:

A01 02

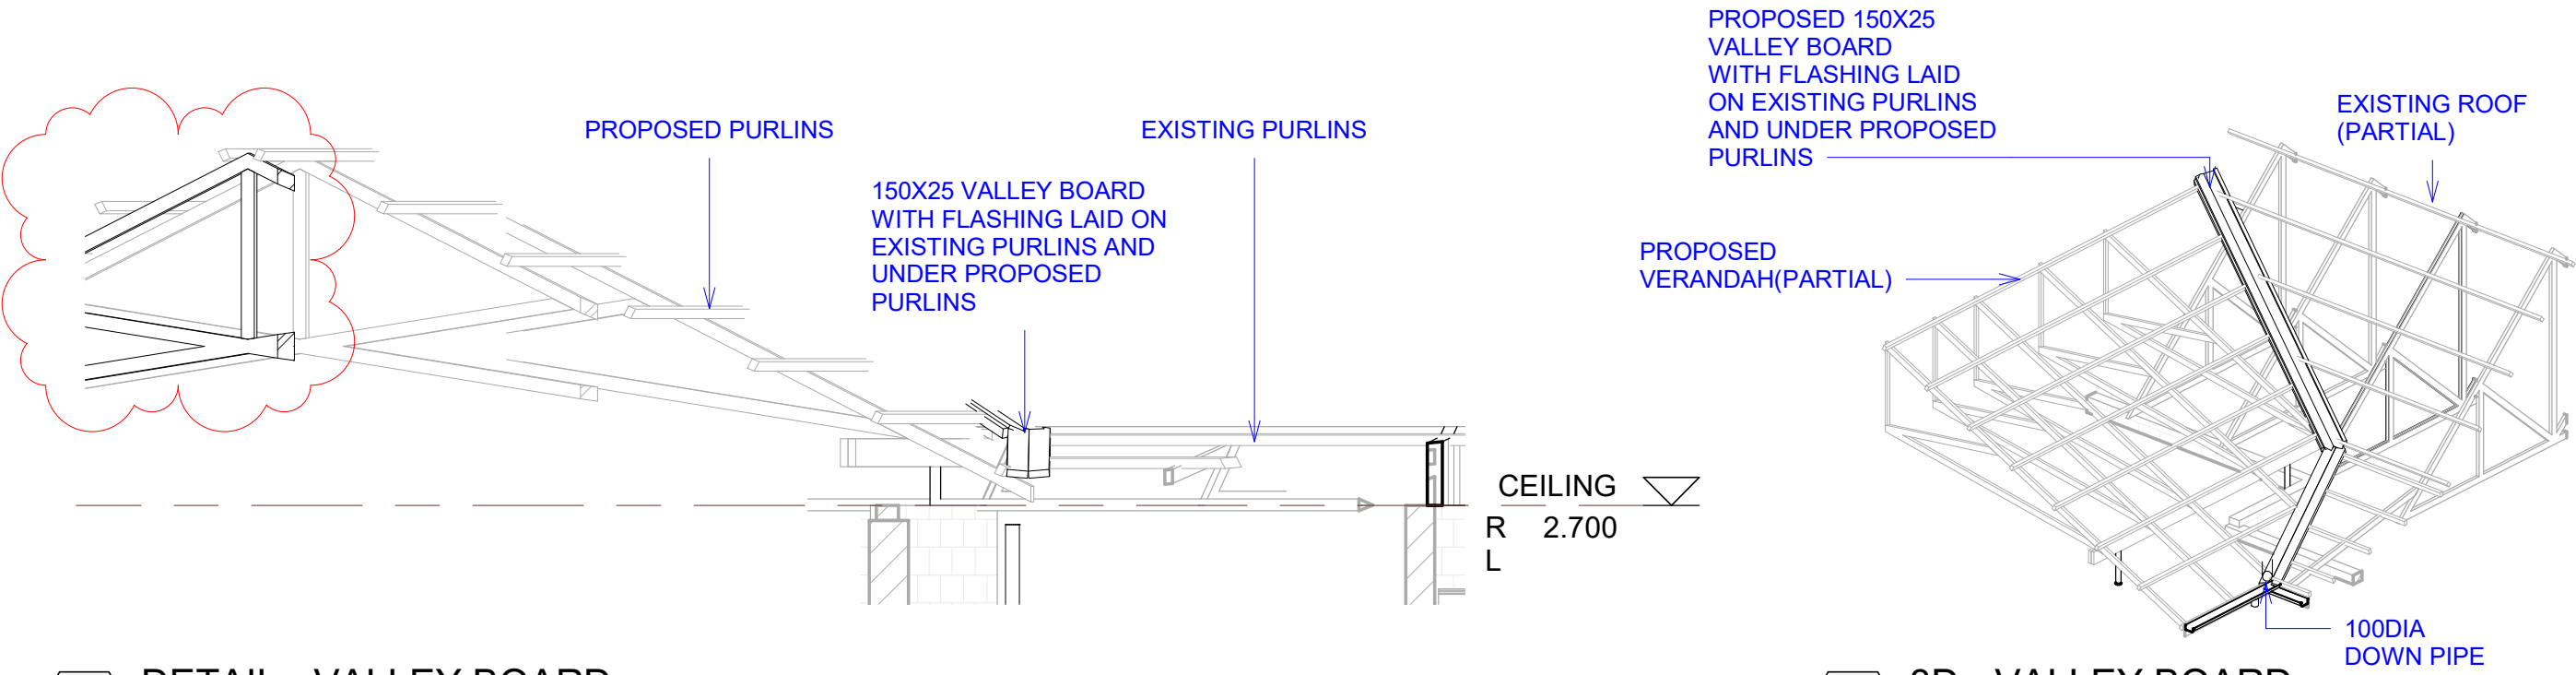


3 DETAIL - VALLEY BOARD

Scale: 1 : 50

2 3D - VALLEY BOARD

Scale: e:

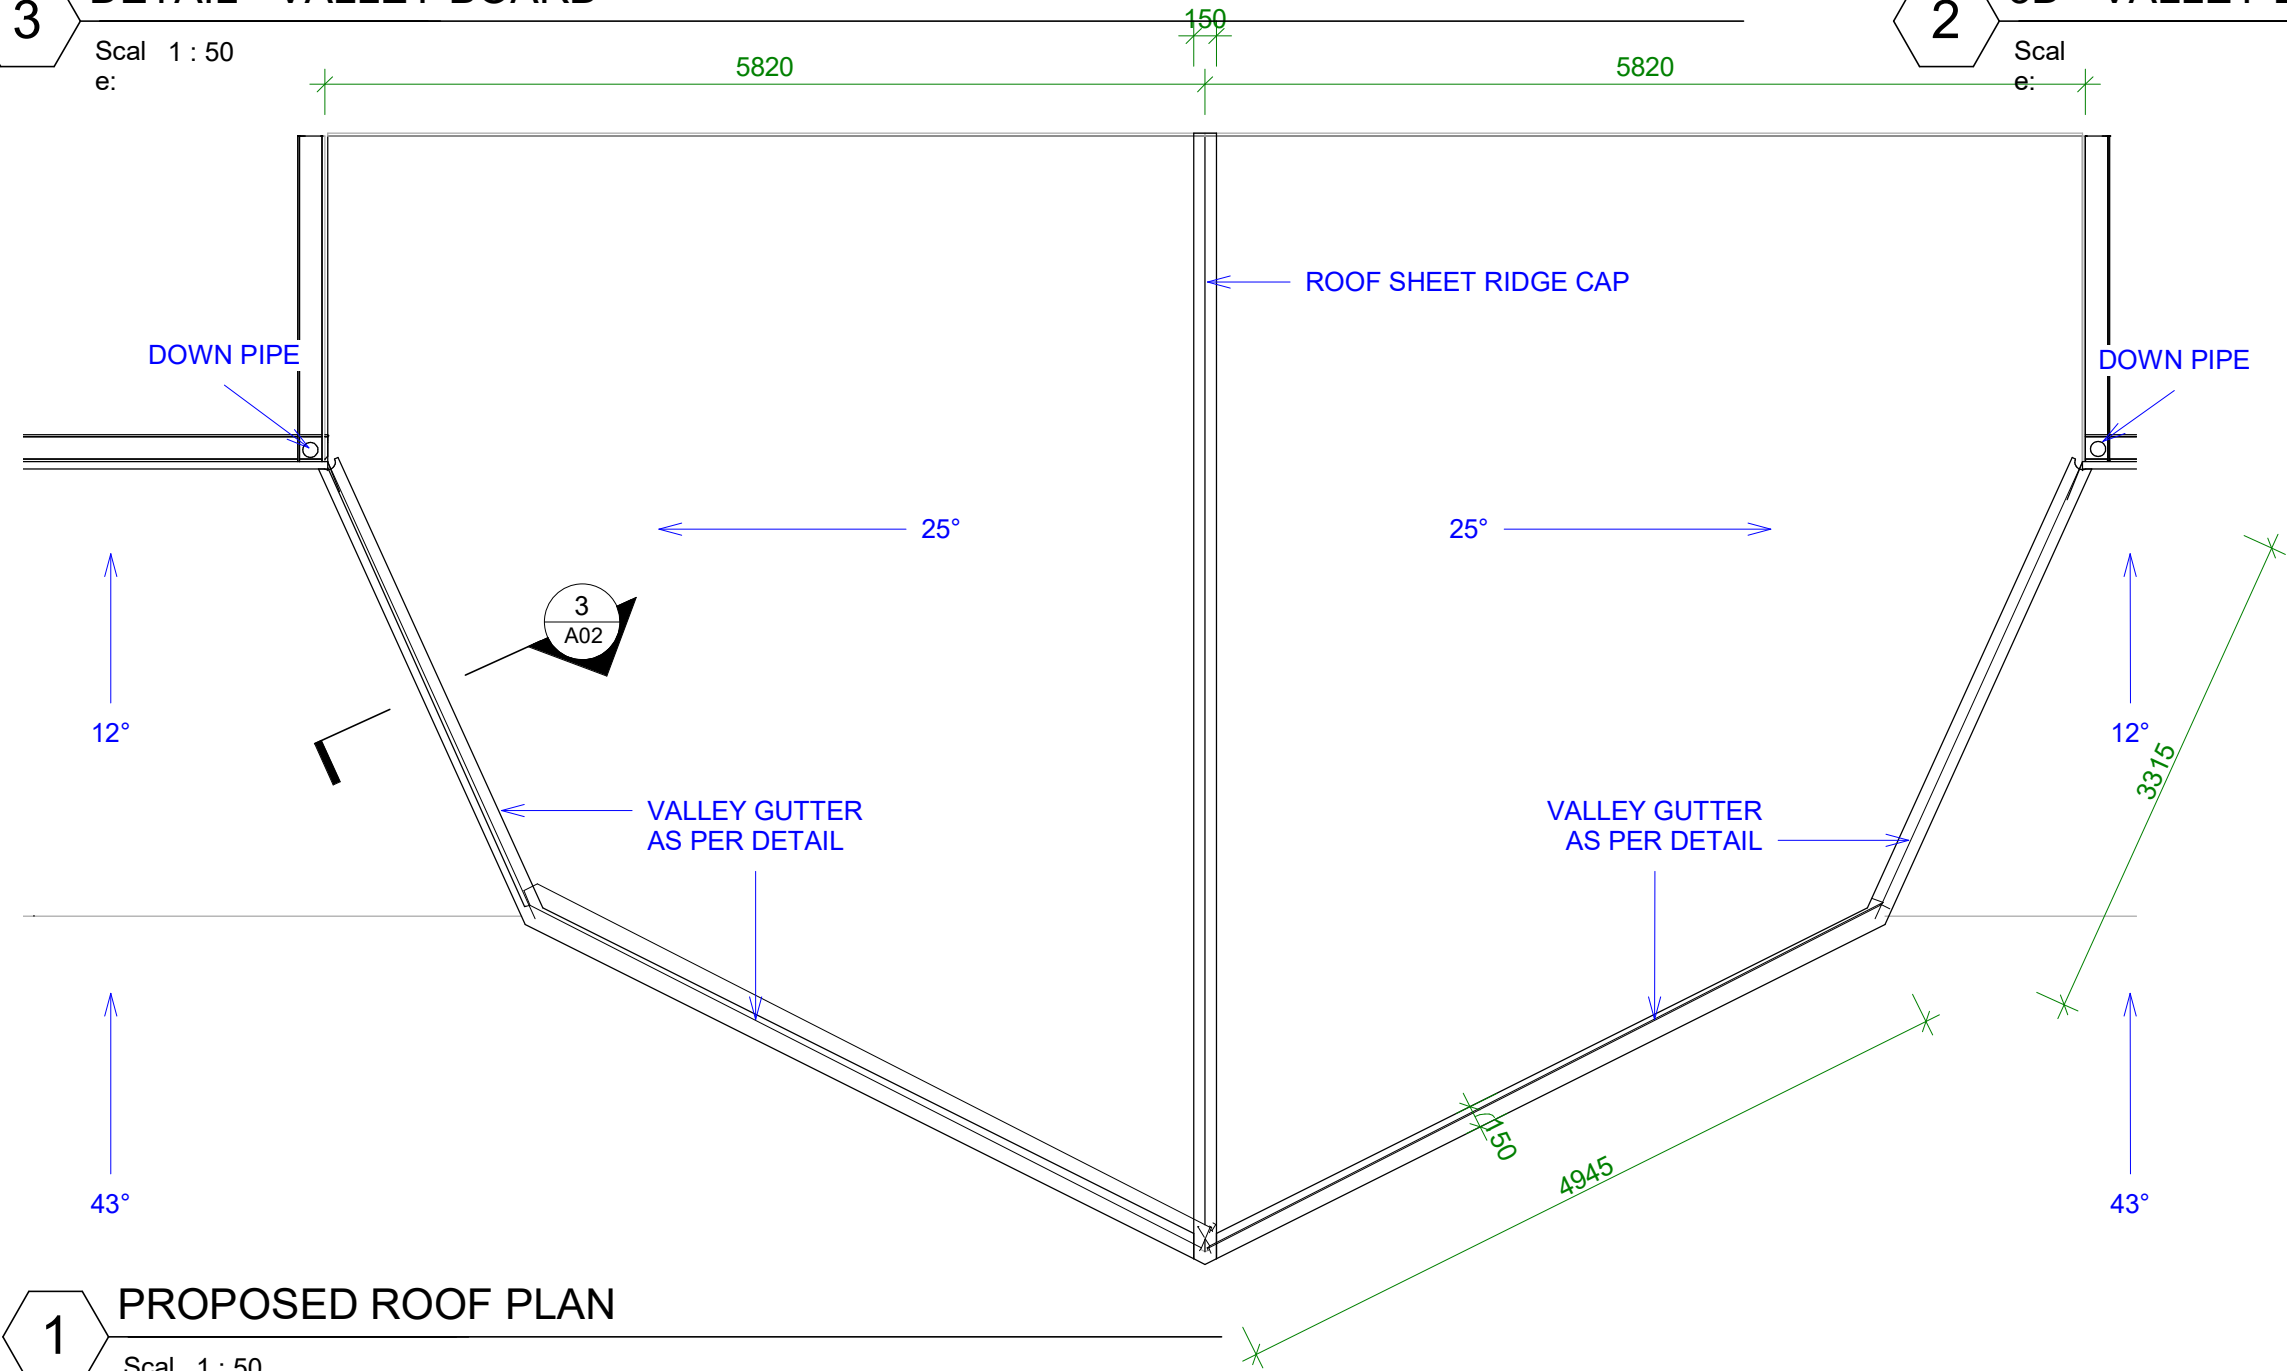

1 PROPOSED ROOF PLAN

Scale: 1 : 50

2 Additional Truss 22/04/12

TDS

TECHNICAL DESIGN SECTION
MINISTRY OF
INFRASTRUCTURE&SUSTAINABLE ENERGY
PO BOX 498
BETIO, TARAWA
REPUBLIC OF KIRIBATI
CENTRAL PACIFIC
PHONE: +686 26192

HM Residence Verandah

CLIENT: MFMRD
PROJECT NO: 142102

DWG TITLE:
PROPOSED ROOF PLAN

DRAWN BY: KB
REVIEWED BY: BR
DATE: 220413
SCALE: 1 : 50



DRAWING NUMBER: ISSUE:

A02

02

Q:\DESIGN\1.2 Current Projects\142102 MFMRD HM Residence Verandah\06 Drawings\0602 Building\1142102 MFMRD HM Residence Verandah_Revised_220412_FOR CPU.rvt

13/04/2022 2:55:53 PM

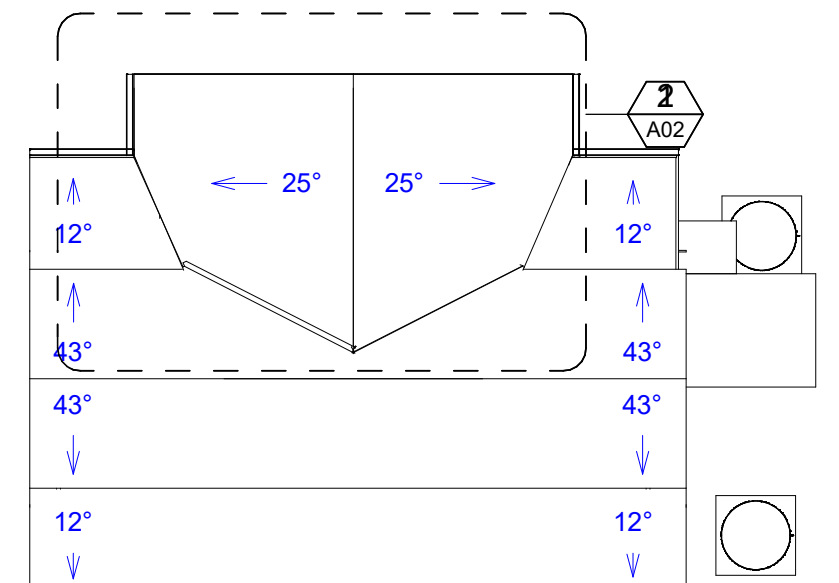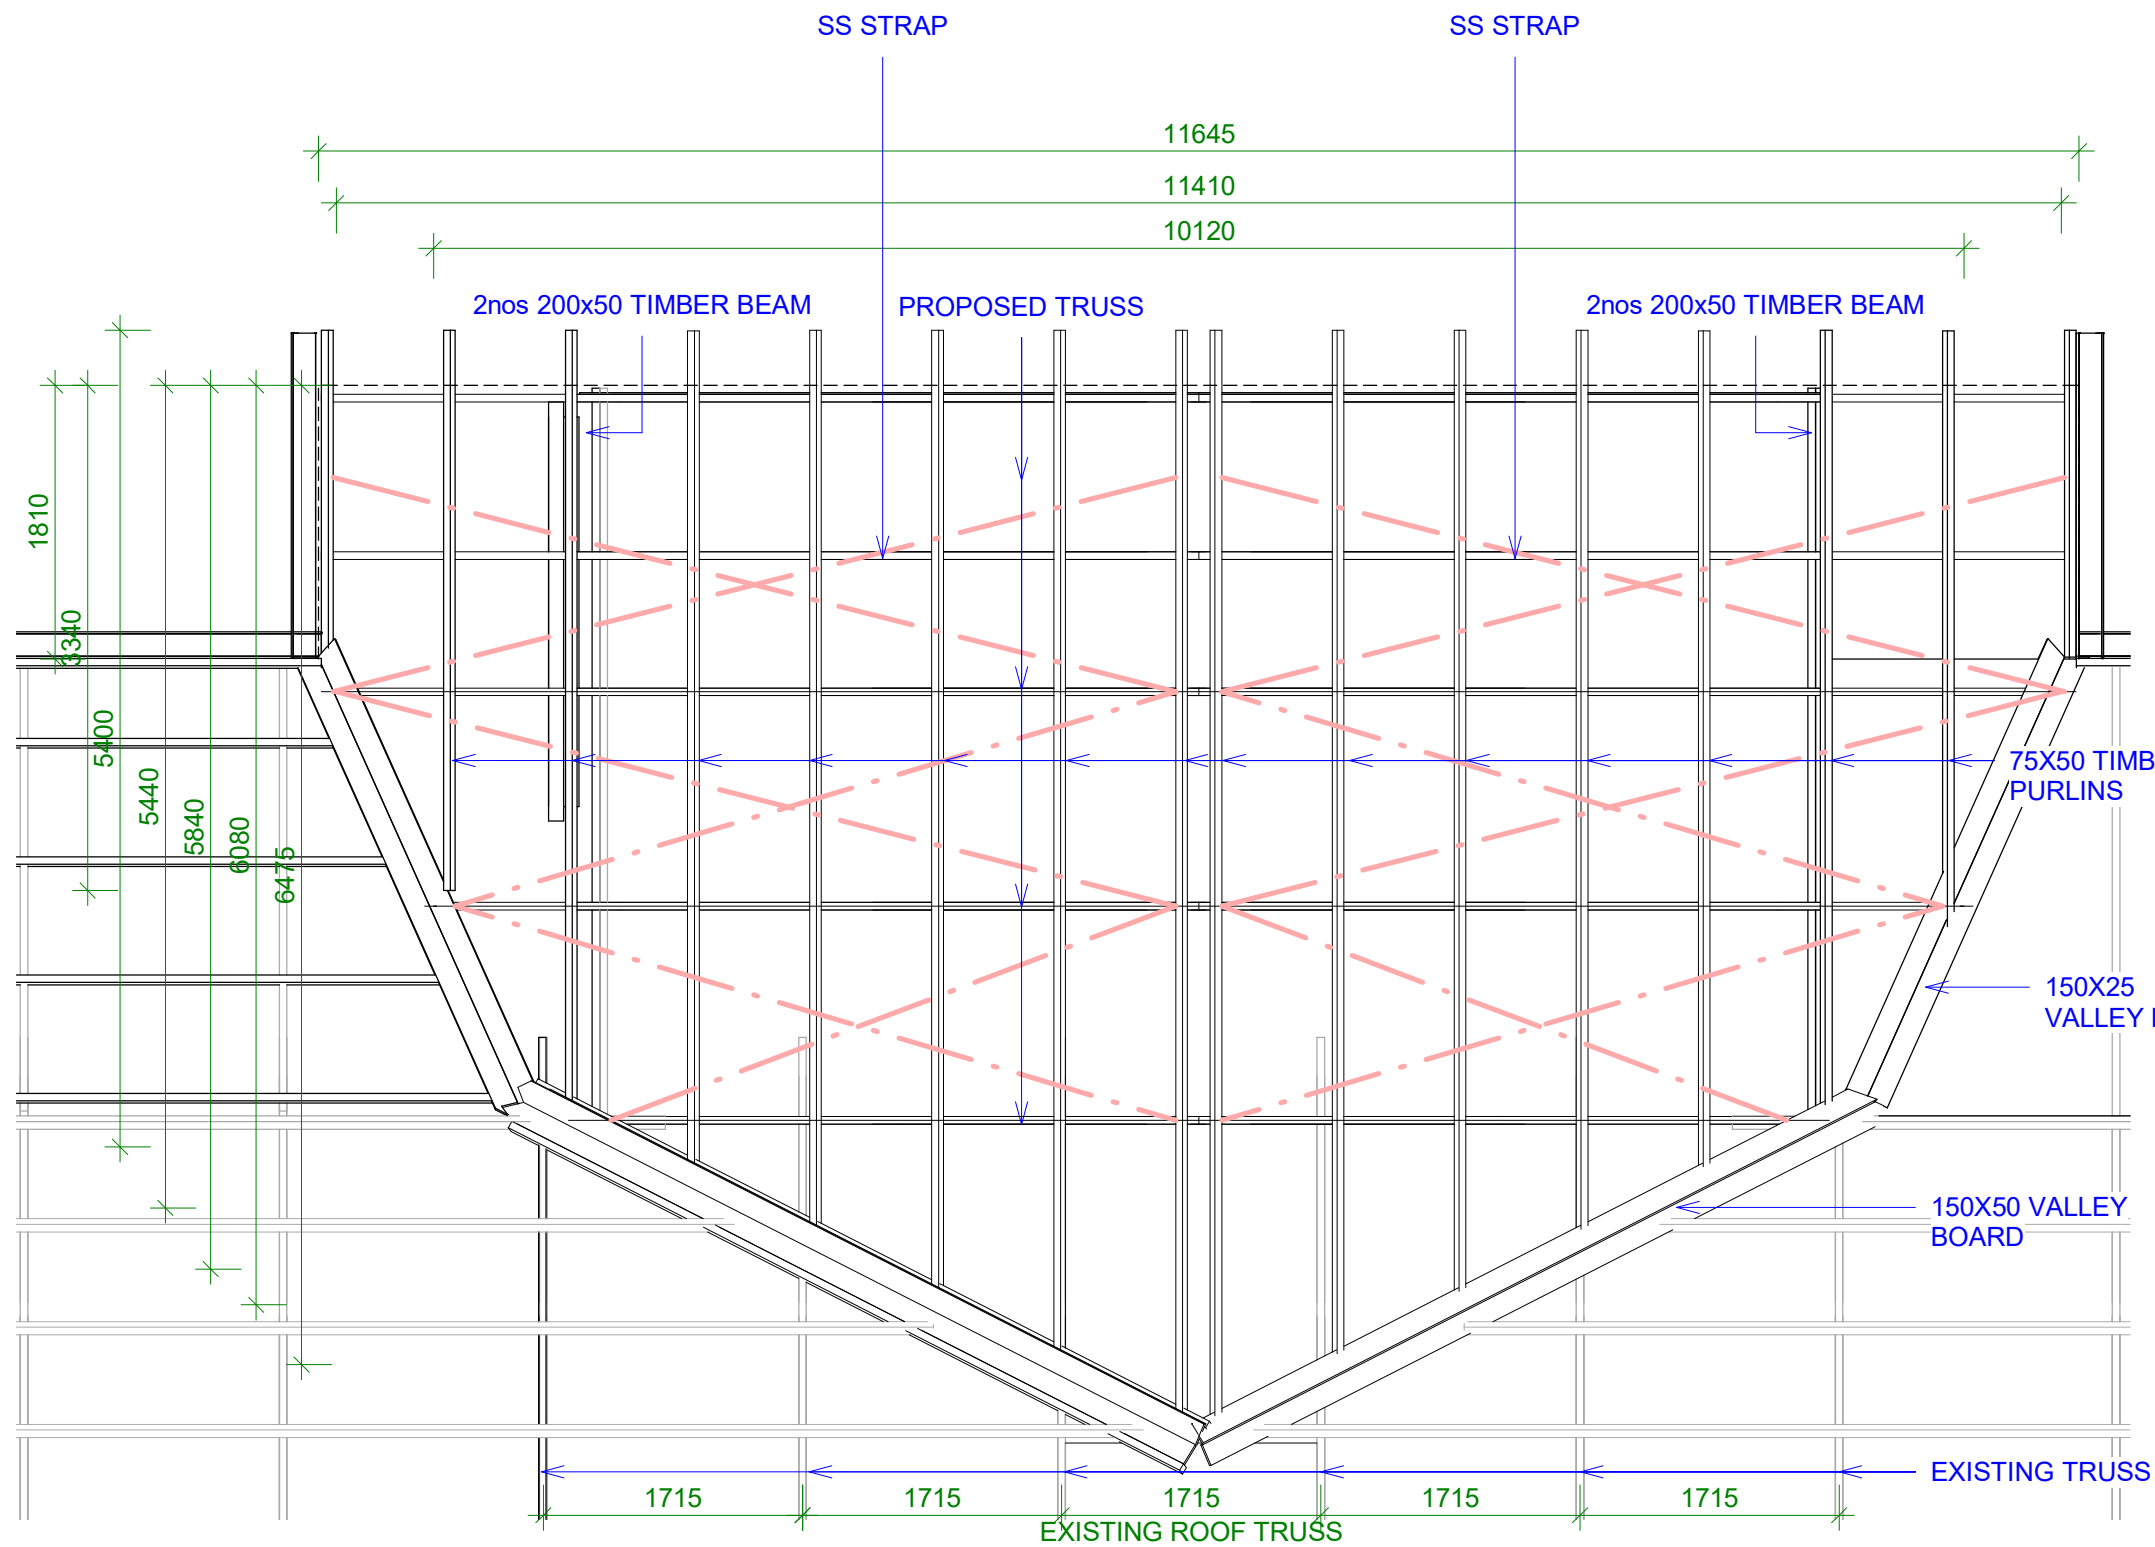

1 OVERALL ROOF PLAN
Scal 1 : 200
e:

2 PROPOSED ROOF FRAMING PLAN

Scal 1 : 50
e:

TDS
TECHNICAL DESIGN SECTION
MINISTRY OF
INFRASTRUCTURE&SUSTAINABLE ENERGY
PO BOX 498
BETIO, TARAWA
REPUBLIC OF KIRIBATI
CENTRAL PACIFIC
PHONE: +686 26192
HM Residence Verandah

CLIENT: MFMRD
PROJECT NO: 142102


DWG TITLE:
**PROPOSED ROOF
FRAMING PLANS**

DRAWN BY: KB
REVIEWED BY: BR
DATE: 220413
SCALE: As indicated

DRAWING NUMBER: ISSUE:


A03

02

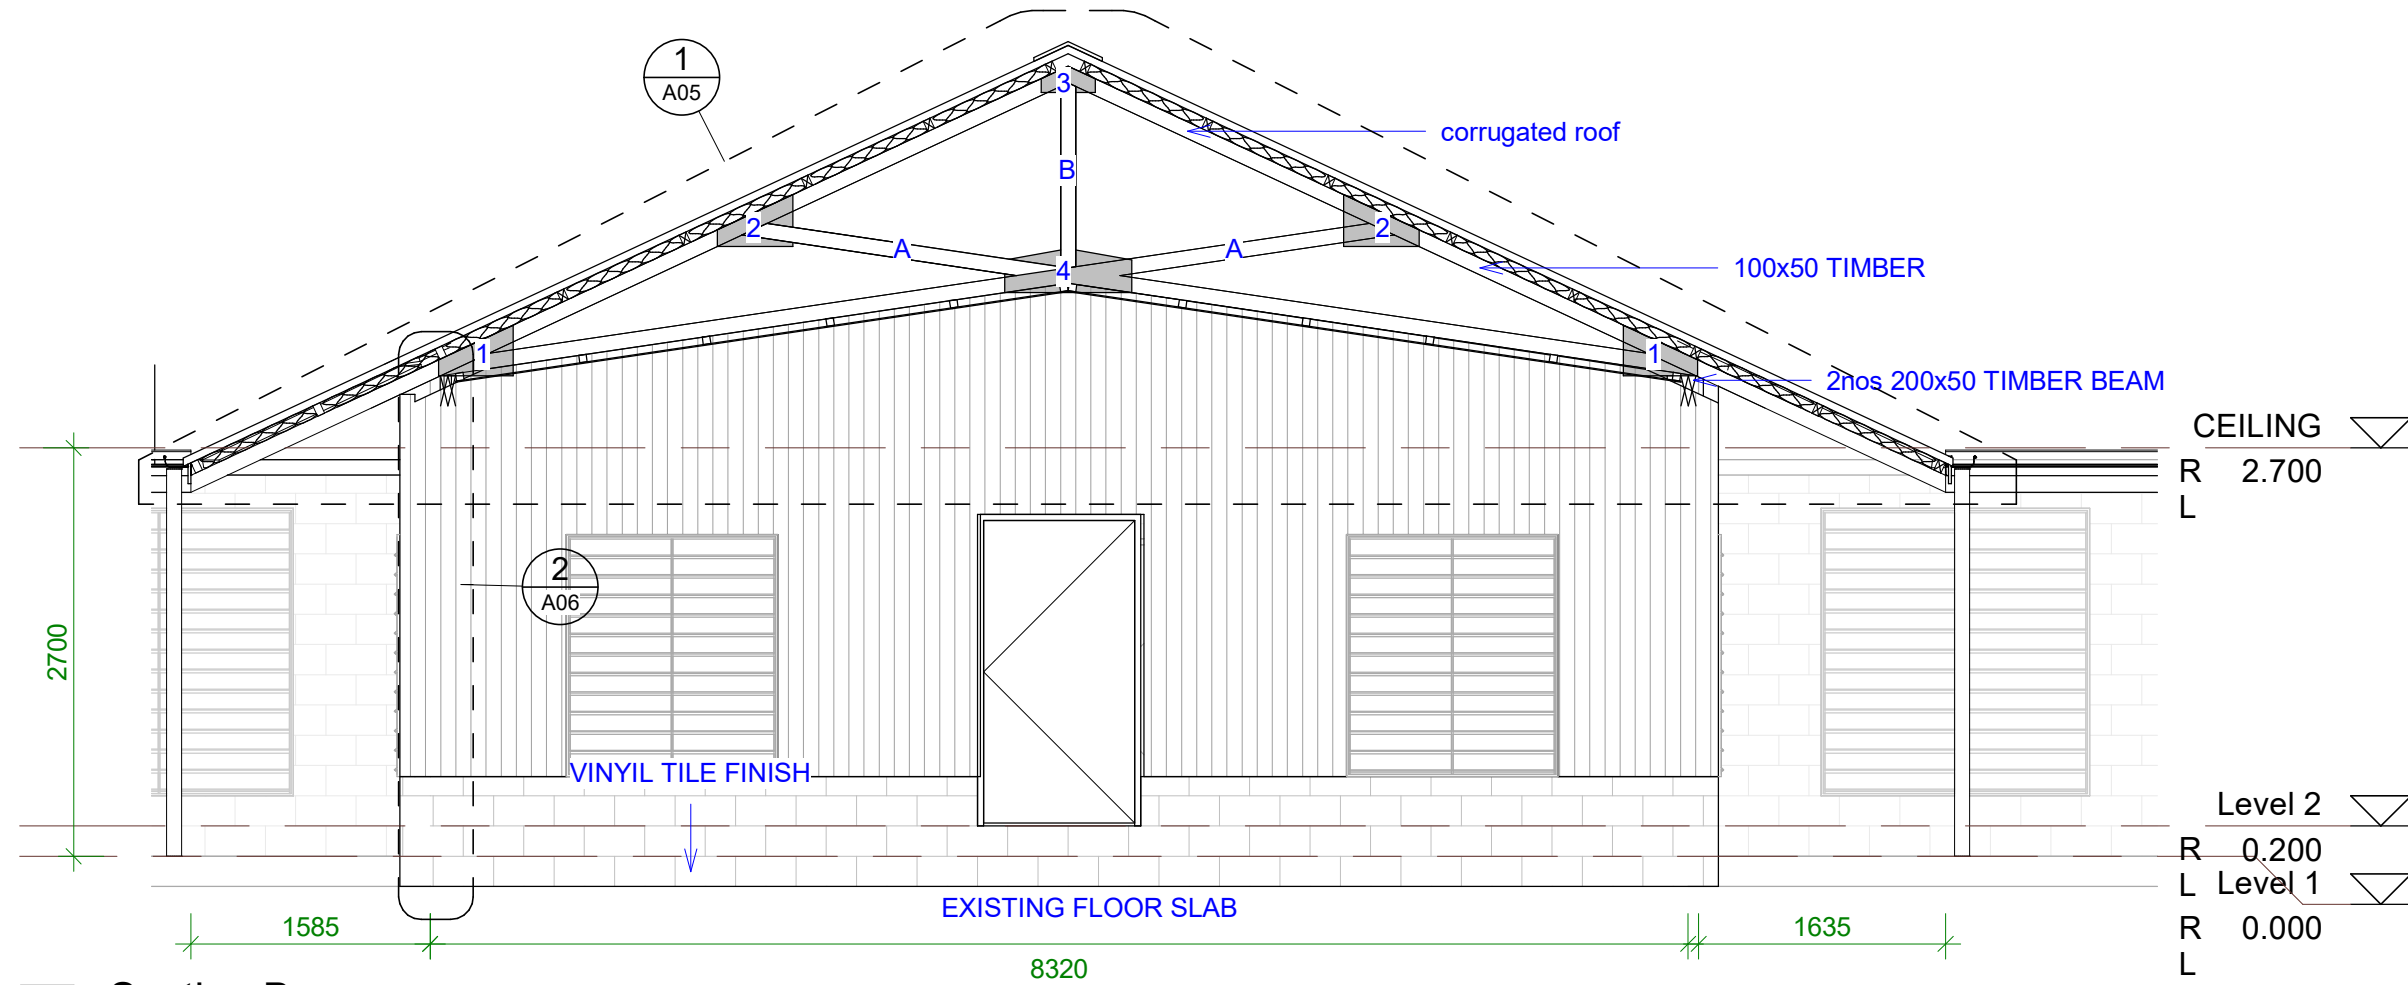

1 Section B

Scal 1 : 50
e:

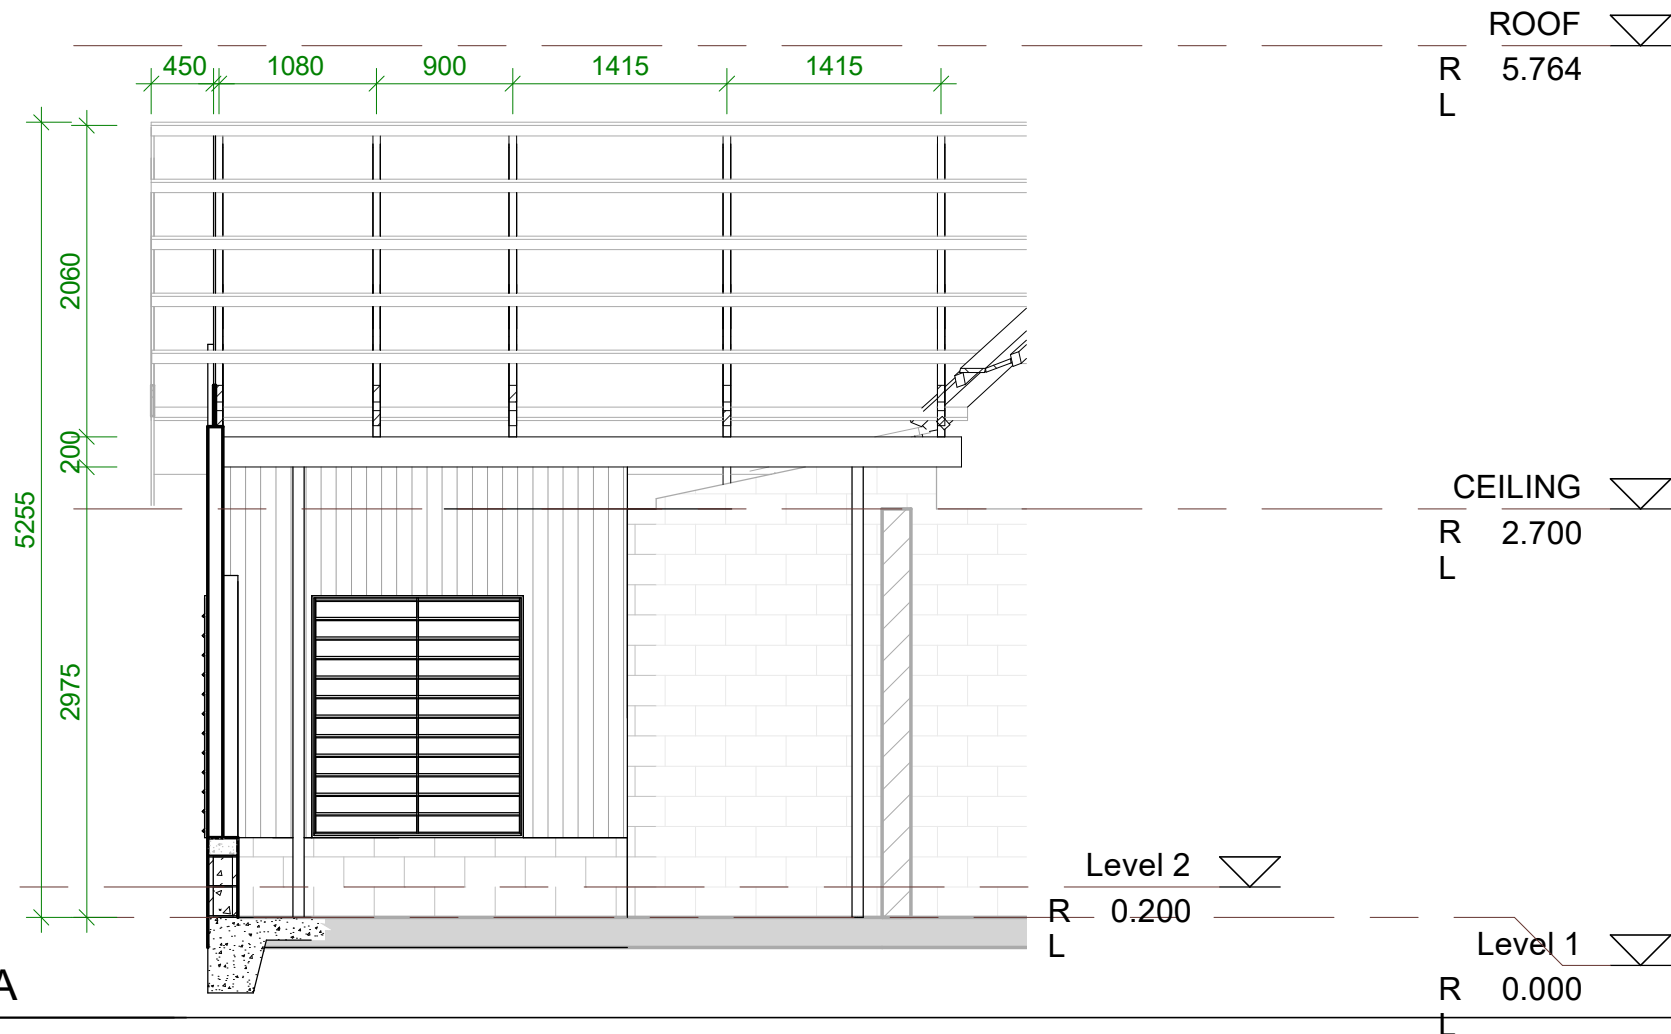

2 Section A

Scal 1 : 50
e:

TDS

TECHNICAL DESIGN SECTION
MINISTRY OF
INFRASTRUCTURE&SUSTAINABLE ENERGY
PO BOX 498
BETIO, TARAWA
REPUBLIC OF KIRIBATI
CENTRAL PACIFIC
PHONE: +686 26192

HM Residence Verandah

CLIENT: MFMRD
PROJECT NO: 142102

DWG TITLE:
SECTION

DRAWN BY: KB
REVIEWED BY: BR
DATE: 220413
SCALE: 1 : 50

DRAWING NUMBER: ISSUE:

A04 02

Q:\DESIGN\1.2 Current Projects\142102 MFMRD HM Residence Verandah\06 Drawings\0602 Building\1142102 MFMRD HM Residence Verandah_Revise_220412_FOR CPU.rvt 13/04/2022 2:55:55 PM

Scal 1 : 50
e:

Scal 1 : 20
e:

Scal
e:

TDS

TECHNICAL DESIGN SECTION
MINISTRY OF
INFRASTRUCTURE & SUSTAINABLE ENERGY
PO BOX 498
BETIO, TARAWA
REPUBLIC OF KIRIBATI
CENTRAL PACIFIC
PHONE: +686 26192

HM Residence Verandah

CLIENT: MFMRD
PROJECT NO: 142102


DWG TITLE:
**DETAIL - TRUSS&
SCHEDULES**

DRAWN BY: KB
REVIEWED BY: BR
DATE: 220413
SCALE: As indicated


DRAWING NUMBER: ISSUE:

A05

02

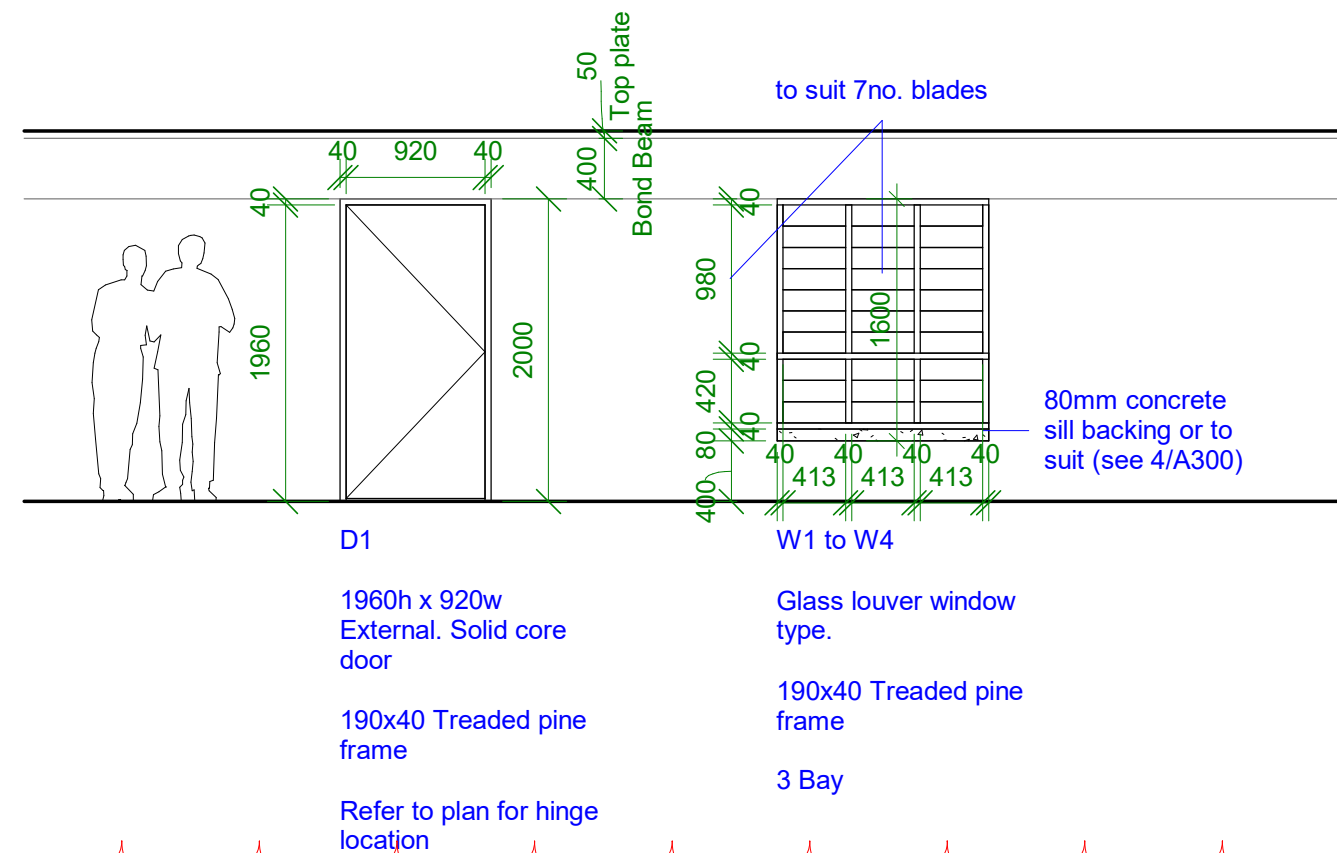

OPENING SCHEDULE

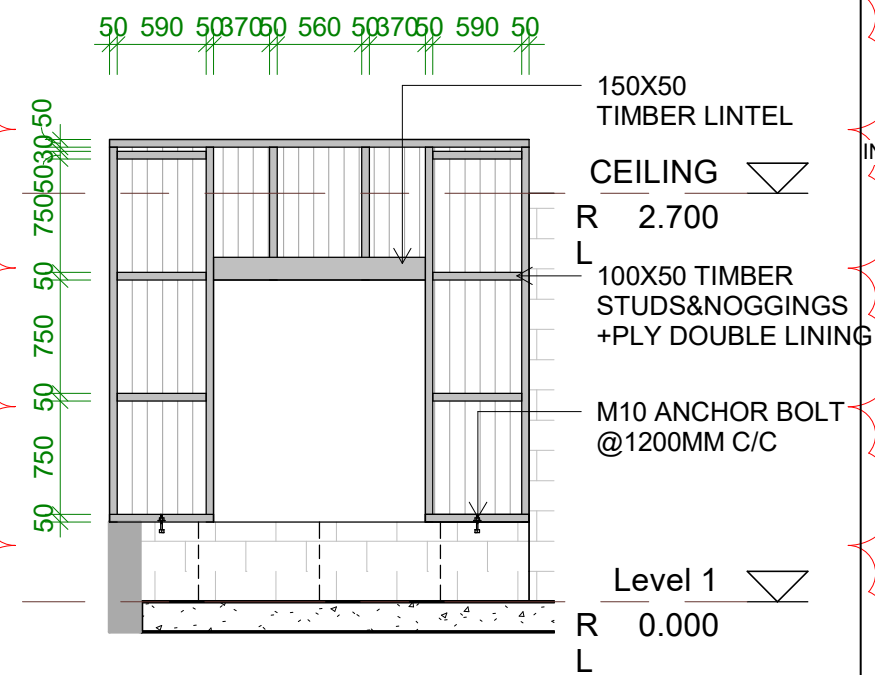

3 FRAME 2&3

Scal 1 : 50

e:

1 Additional Verandah Wall 22/04/12

TDS
TECHNICAL DESIGN SECTION
MINISTRY OF
INFRASTRUCTURE&SUSTAINABLE ENERGY
PO BOX 498
BETIO, TARAWA
REPUBLIC OF KIRIBATI
CENTRAL PACIFIC
PHONE: +686 26192

CLIENT: MFMRD
PROJECT NO: 142102


DWG TITLE:
DETAIL - TIMBER
FRAME

DRAWN BY: KB
REVIEWED BY: BR
DATE: 220413
SCALE: 1 : 50

DRAWING NUMBER: ISSUE:


A07 02

Q:\DESIGN\1.2 Current Projects\142102 MFMRD HM Residence\0602 Building\1142102 MFMRD HM Residence

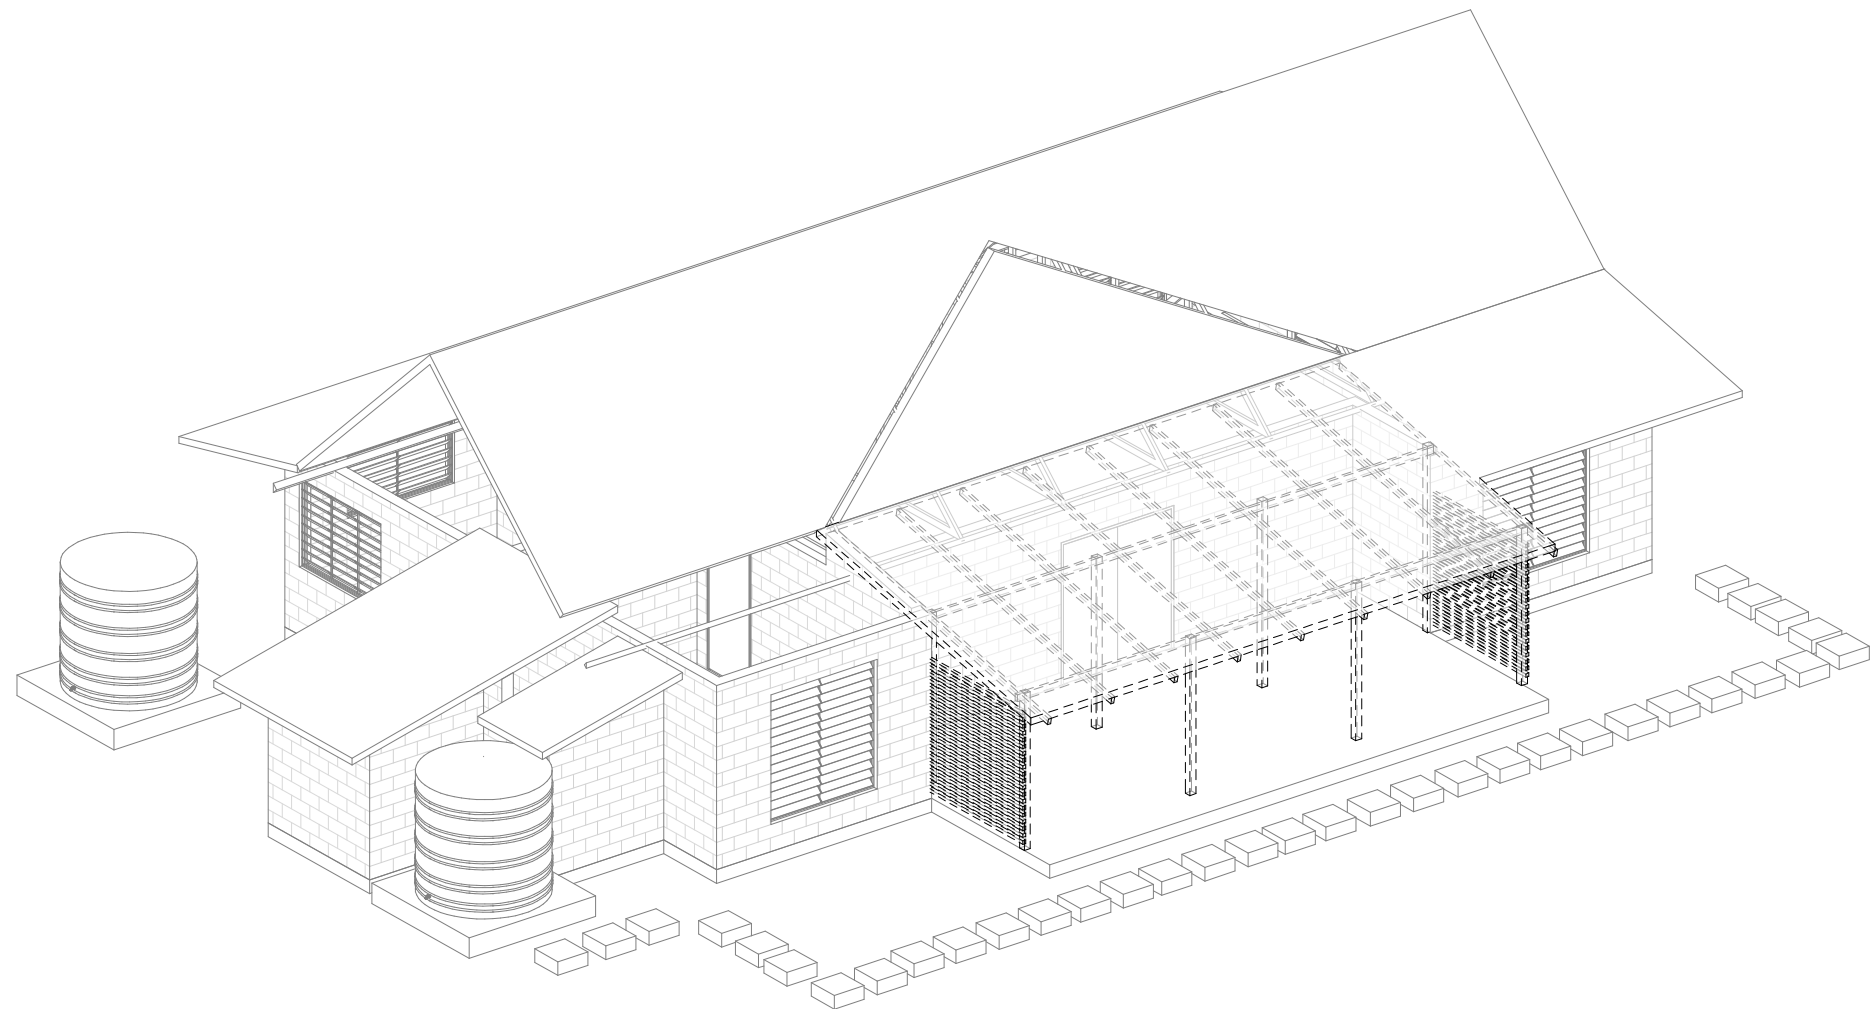

2 EXISTING&DEMO MODEL

Scale:

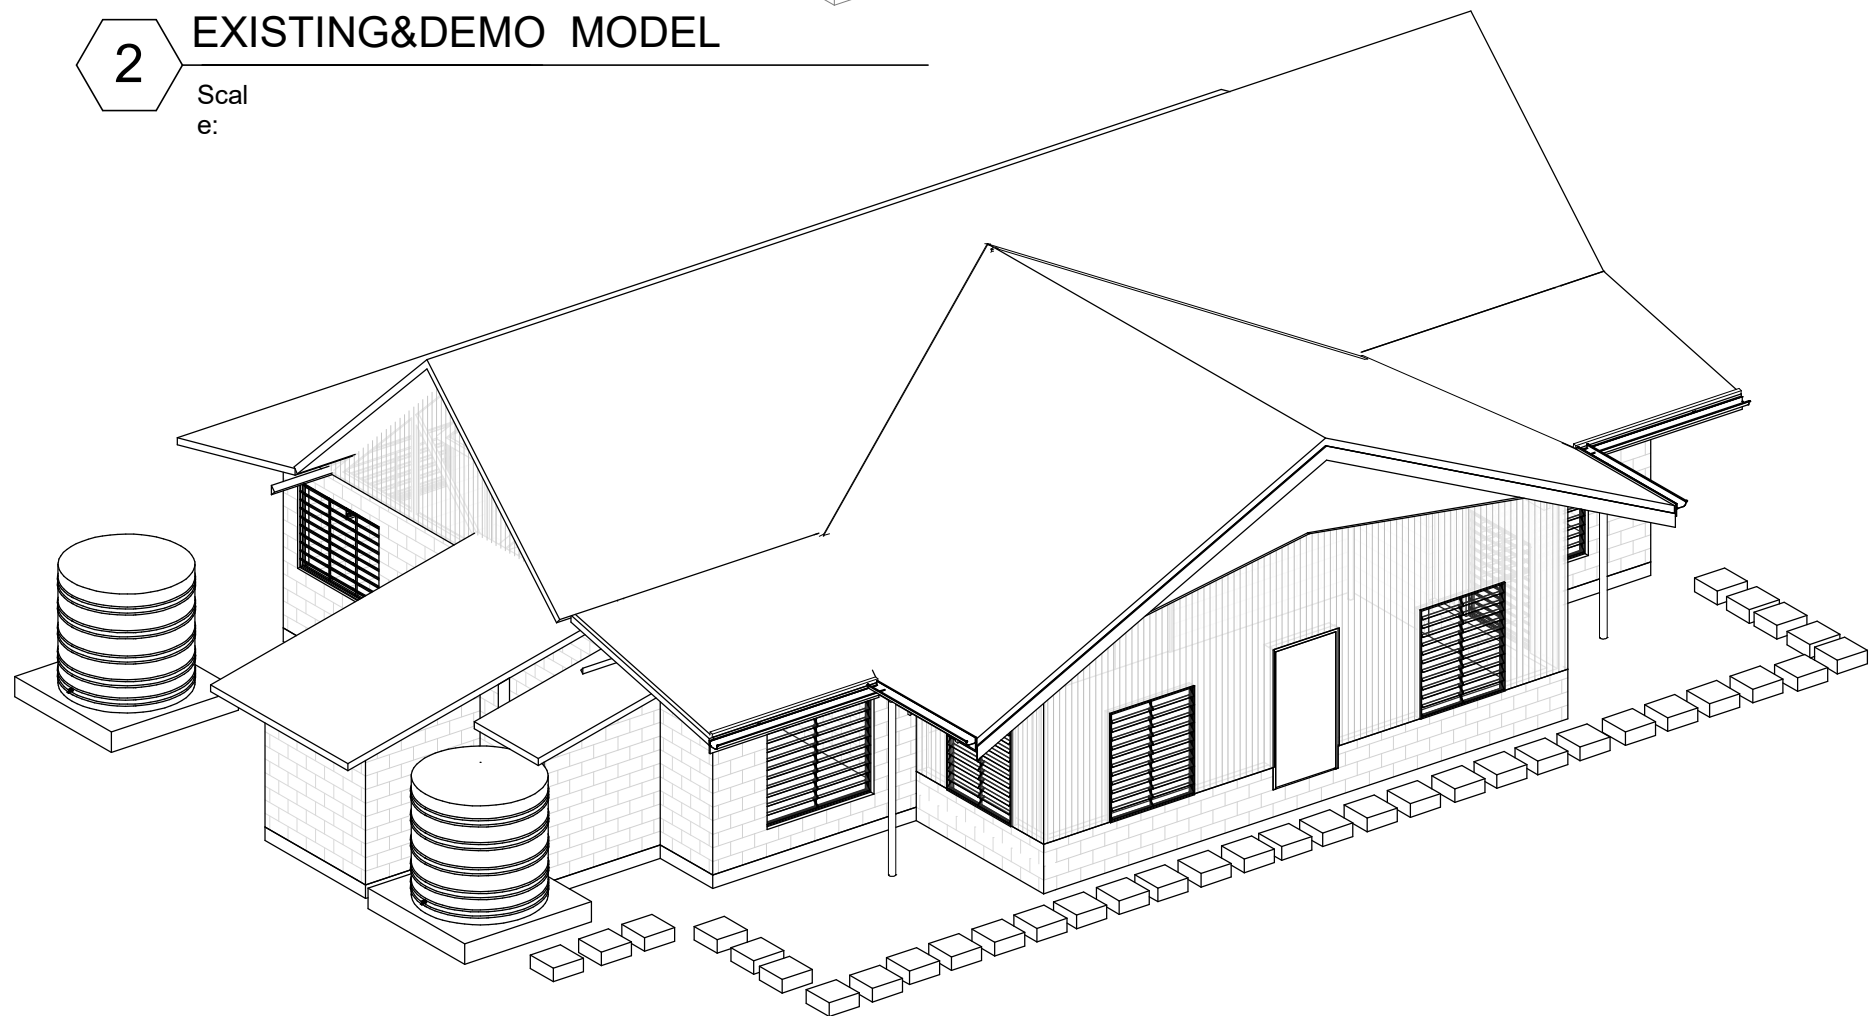

1 PROPOSED MODEL

Scale:

TDS

TECHNICAL DESIGN SECTION
 MINISTRY OF
 INFRASTRUCTURE&SUSTAINABLE ENERGY
 PO BOX 498
 BETIO, TARAWA
 REPUBLIC OF KIRIBATI
 CENTRAL PACIFIC
 PHONE: +686 26192

HM Residence Verandah

CLIENT: MFMRD

PROJECT NO: 142102

DWG TITLE:

3D MODEL

DRAWN BY: KB

REVIEWED BY: BR

DATE: 220413

SCALE:

DRAWING NUMBER: A08

ISSUE: 02

C:\DESIGN\1.2 Current Projects\142102 MFMRD HM Residence Verandah\06 Drawings\0602 Building\1142102 MFMRD HM Residence Verandah_Revise_220412_FOR CPU.rvt
 13/04/2022 2:26:01 PM

CONSTRUCTION SPECIFICATION

ALL SETOUT AND CONSTRUCTION DIMENSIONS ARE TO BE CHECKED ON SITE

PRIOR TO STARTING ANY WORKS BY THE CONTRACTOR OR SUB-CONTRACTORS.

REFER ANY DISCREPENCIES TO ARCHITECT FOR RESOLUTION.

ROOF PLUMBING

ROOFING

STANDARD CORRUGATED STEEL ROOFING - COLOUR BOND ROOFING SHEET

FIX STEEL ROOFING TO TIMBER ROOFING BATTENS WITH GALVANISED ROOFING

SCREWS

RIDGE AND BARGE CAPPINGS

FOLDED STEEL SHEET - COLOUR BOND

FIX CAPPINGS THROUGH STEEL ROOFING TO TIMBER ROOFING BATTENS WITH

GALVANISED ROOFING SCREWS

ROOF FRAMING

ALL TIMBER FRAMING SHOULD BE TERMITE TREATED AND COMPLY WITH AS 1684.

TIMBER TRUSSES AND RAFTERS

REFER TO SECTIONS AND DETAILS FOR TRUSSES/RAFTER DESIGN.

BE SURE TO INSTALL ALL BOTTOM CHORD TIES, ROOF BRACING AND TIES TO

TIMBER BEAM.

CEILING BATTENS/NOGGINGS

NAIL FIX 50x50 CEILING BATTENS/NOGGINGS TO UNDERSIDE OF TIMBER

TRUSSES AT 600 CENTRES MAX IN BOTH DIRECTIONS.

LININGS AND TRIM

CEILING LINING

1200X2400x6mm PLYWOOD SHEETS NAILED TO CEILING BATTENS AT 300

CENTRES IN CENTRE OF SHEET AND AT 150 CENTRES AT SHEET EDGES.

ARCHITRAVES, SKIRTINGS AND CORNICE TRIMS

42x12mm DRESSED PINE. PAINT FINISH.

INTERNAL FINISHES

CONC
CONCRETE FLOOR. BROOM FINISH.

FT
SELECTED FLOOR TILE

EXTERNAL PAINTING

INTERNAL PAINTING

ONLY PREMIUM QUALITY PAINTS TO BE USED

1 Construction Specification

Scale: 1 : 20

TDS

TECHNICAL DESIGN SECTION
MINISTRY OF
INFRASTRUCTURE&SUSTAINABLE ENERGY
PO BOX 498
BETIO, TARAWA
REPUBLIC OF KIRIBATI
CENTRAL PACIFIC
PHONE: +686 26192

HM Residence Verandah

CLIENT: MFMRD
PROJECT NO: 142102

DWG TITLE:
CONSTRUCTION
SPEC'S

DRAWN BY: KB
REVIEWED BY: BR
DATE: 220413
SCALE: 1 : 20

DRAWING NUMBER: ISSUE:

A09

02