



DRAWING LIST

- design brief
- S01 COVER SHEET
- S02 SITE LOCATION
- S03 SITE PLANS
- S05 GL-FLOOR PLAN
- S06 LEVEL 1_PLAN
- S07 LEVEL 2_PLAN
- S11 LEVEL 2-ELECTRICAL PLAN
- S12 ELECTRICAL LEGEND
- S13 PLUMBING PLAN
- S13.1 PLUMBING PLAN - Processing Area
- S17 ROOF PLAN
- S020 ELEVATIONS
- S030 SECTIONS
- S31 ROOF DETAILS
- S41 3D VIEWS
- SG SG001-SG009 Water & Sanitation Guidelines (6 separate pages)



architectural Design, civil & structural Engineering, build-works Costing Consultants
e: consult@DECons.com | m: +686 73069657 | facebook: DECons page

Bikenibeu Processing Plant

CLIENT: CPPL
PROJECT NO: GB2311

DWG TITLE:
COVER SHEET


DRAWN by: ttebau
REVIEWED by: ttebau
DATE: 051225
SCALE:

DRAWING NUMBER: S01
ISSUE: Construction Design

COPYRIGHT
All rights reserved. This drawing set or any part of it shall not be reproduced or used in any manner whatsoever without the express written permission of DECons.

C:\Users\4090\OneDrive\Documents\work\work\2026\GB2311.1 - CPPL Bikenibeu Processing Plant\005 Drawing\03 sheet by ttebau\GB2311.1 - CPPL Bikenibeu Processing Plant_280121.rvt

21/01/2026 3:57:32 PM

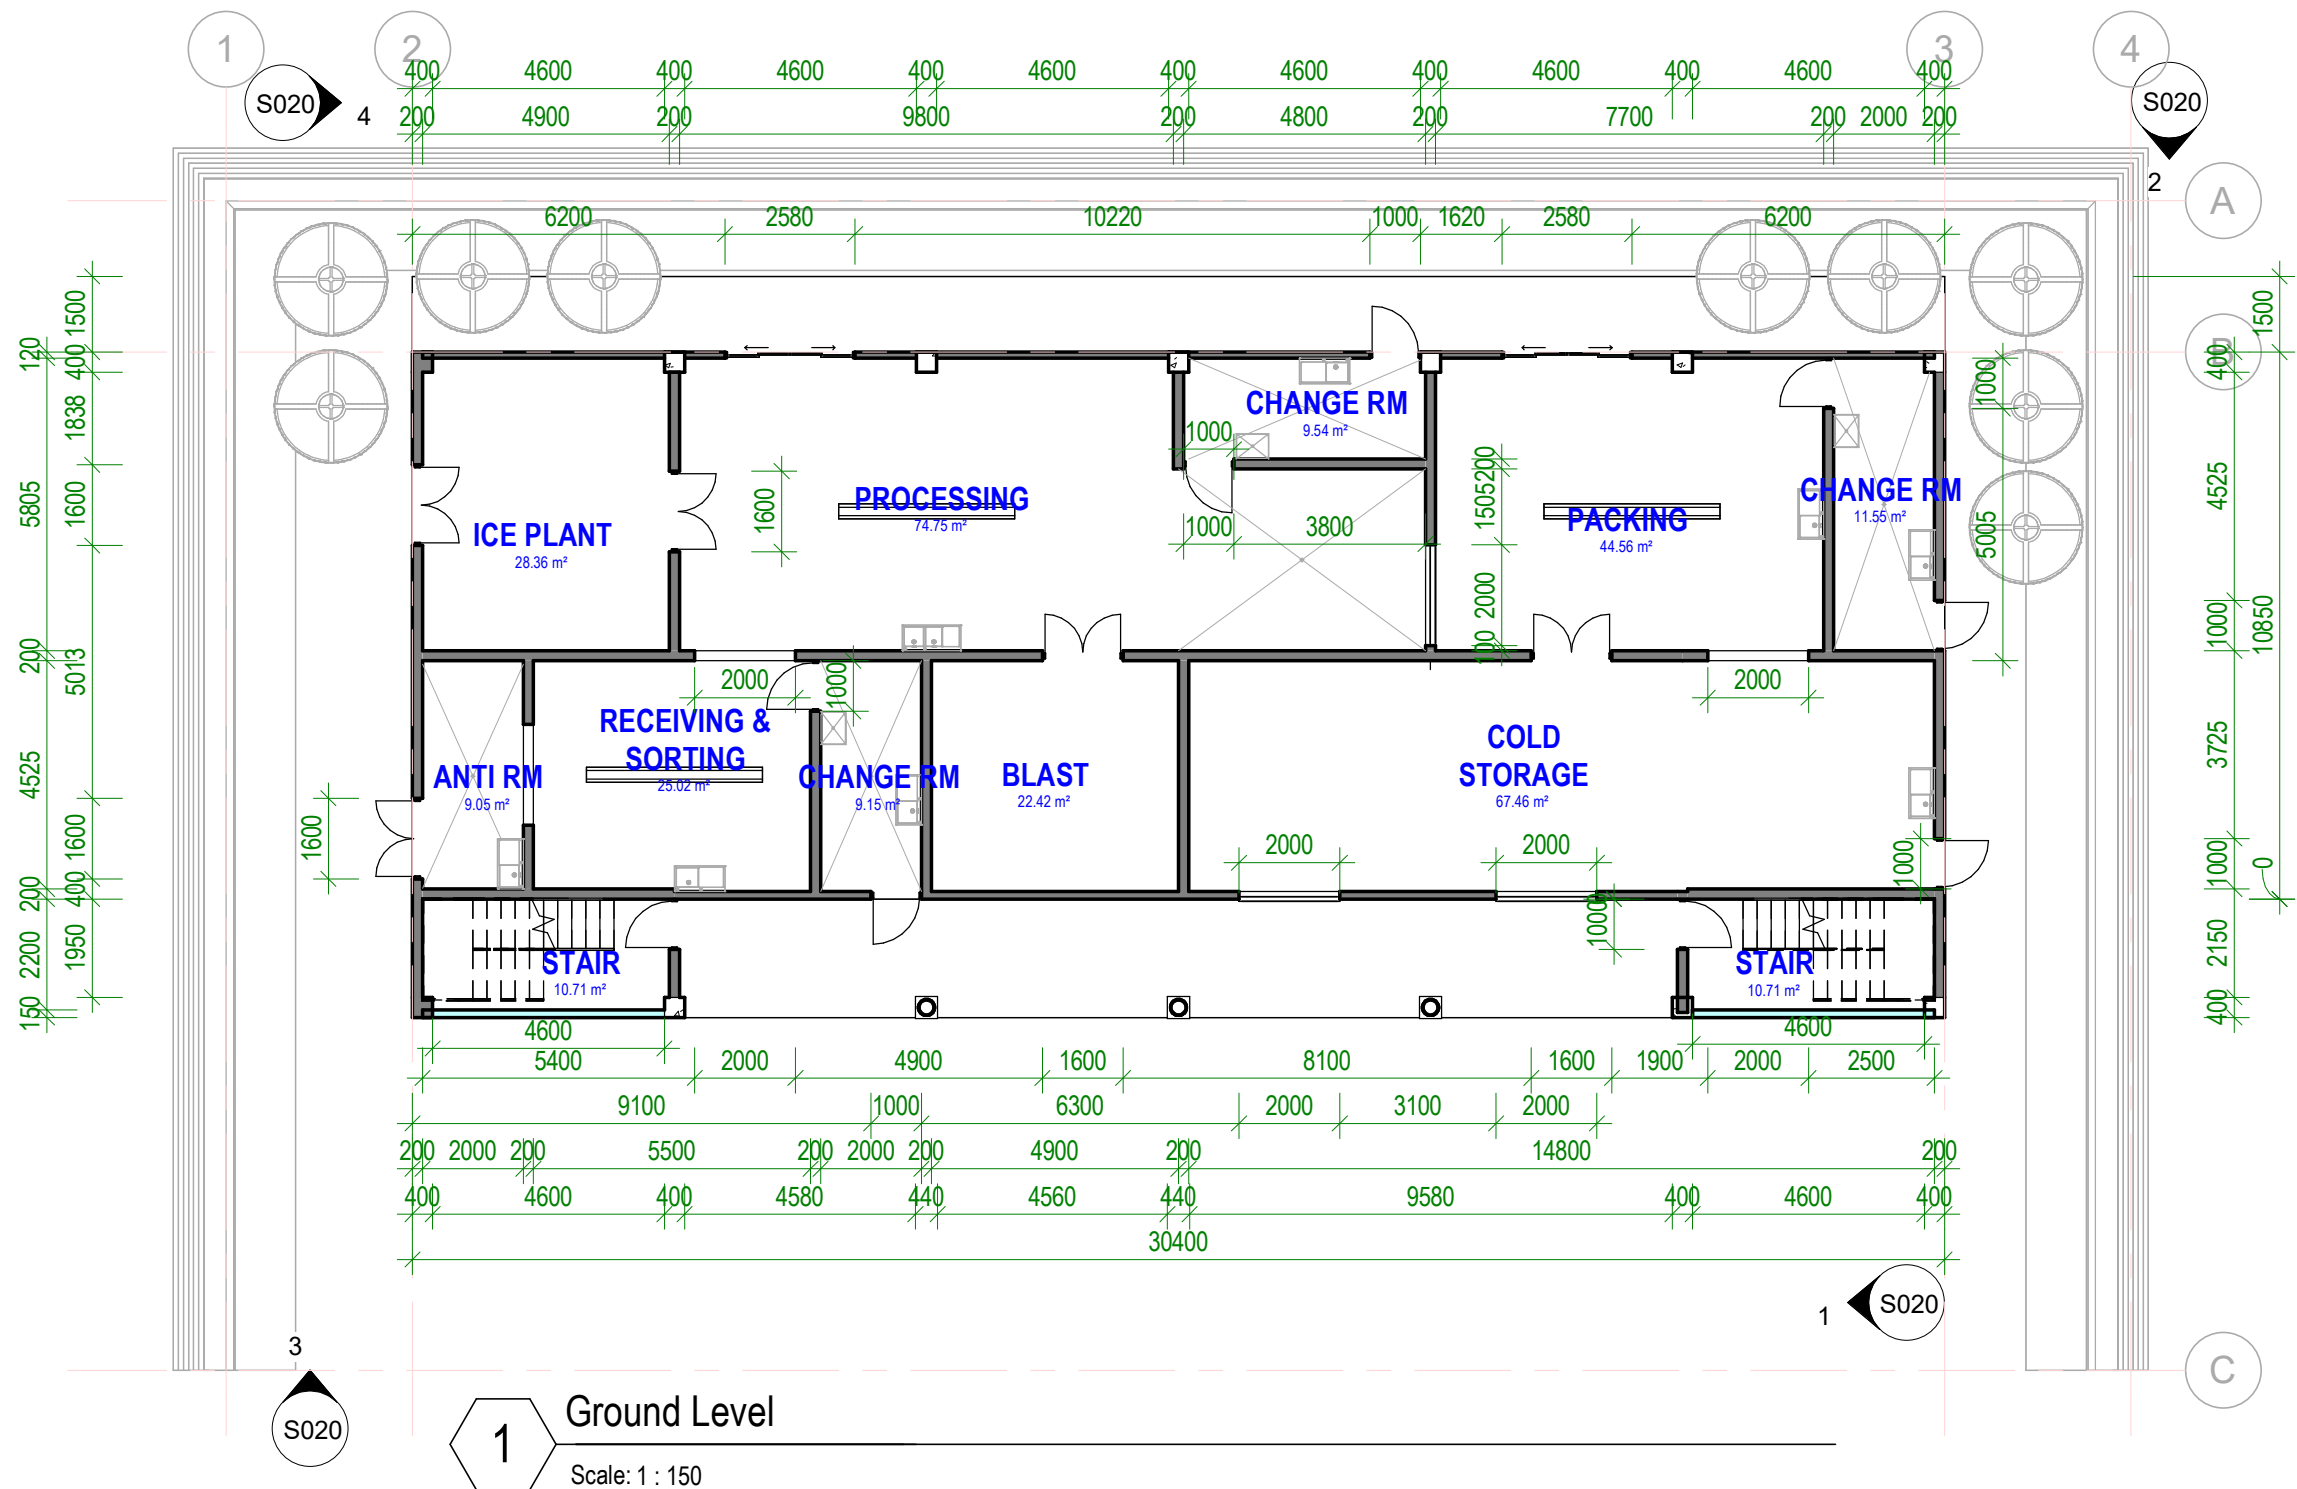

Bikenibeu Processing Plant


CLIENT: CPPL
PROJECT NO: GB2311

DWG TITLE:
GL-FLOOR PLAN

DRAWN by: ttebau
REVIEWED by: ttebau
DATE: 05/10/25
SCALE: 1 : 150

DRAWING NUMBER: S05
ISSUE: Construction Design



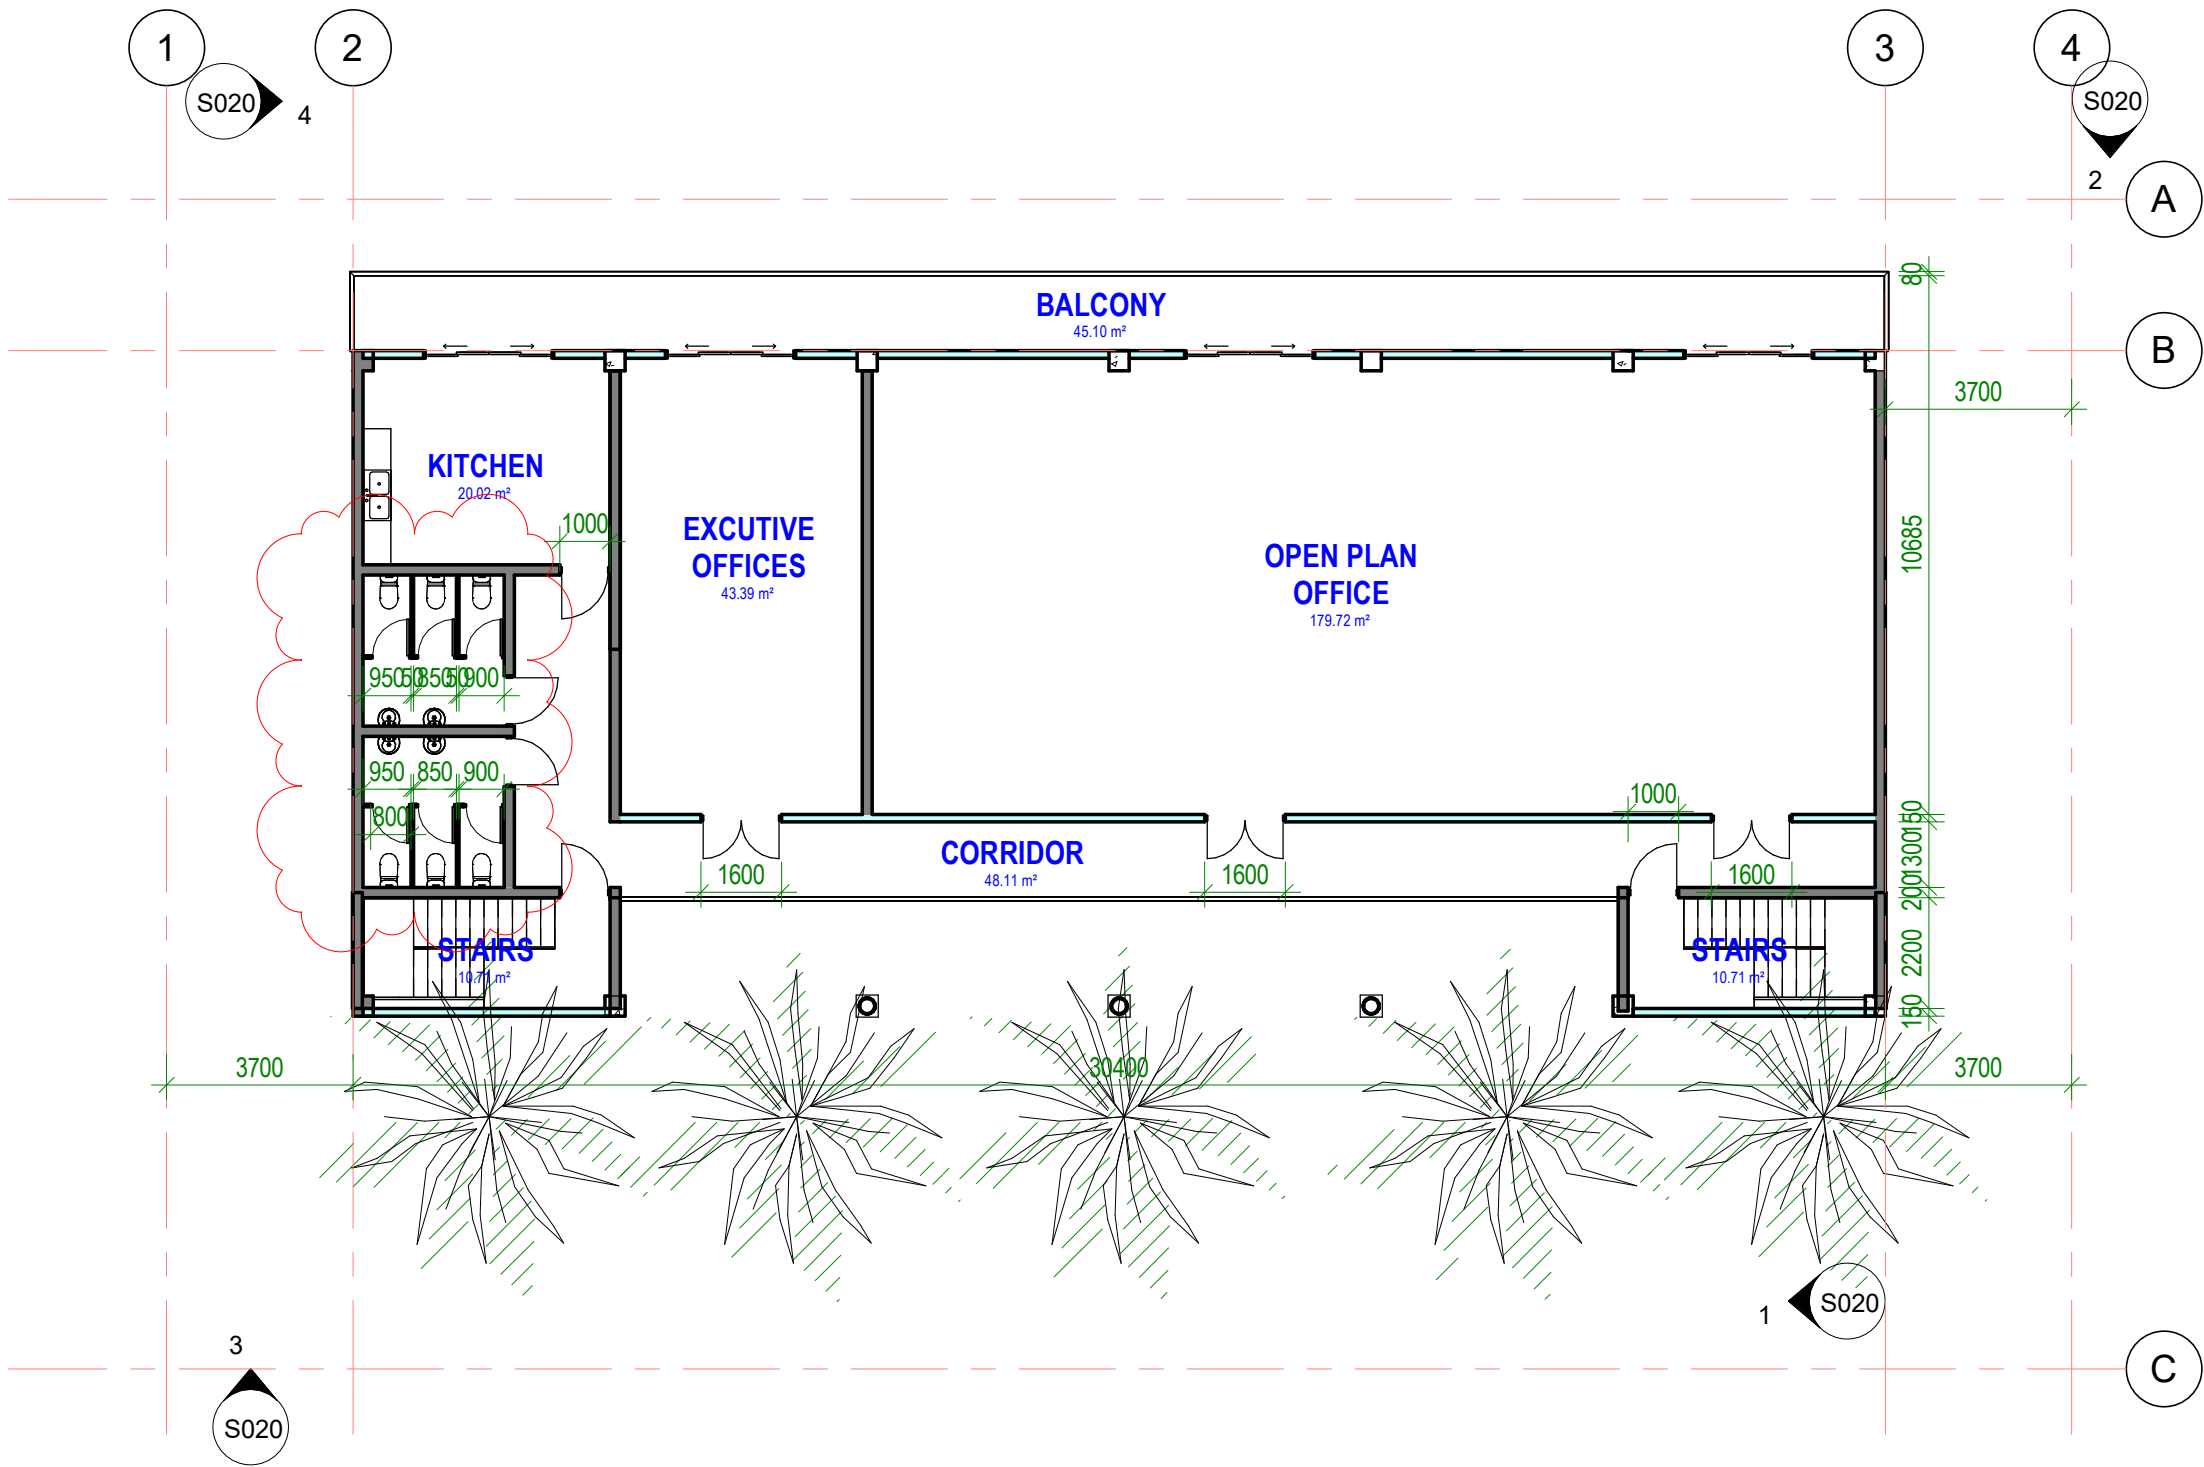

1 Level 1
Scale: 1 : 150



Bikenibeu Processing Plant


CLIENT: CPPL
PROJECT NO: GB2311

DWG TITLE:
LEVEL 1_PLAN

DRAWN by: ttebau
REVIEWED by: ttebau
DATE: 051225
SCALE: 1 : 150

DRAWING NUMBER: S06
ISSUE: Construction Design



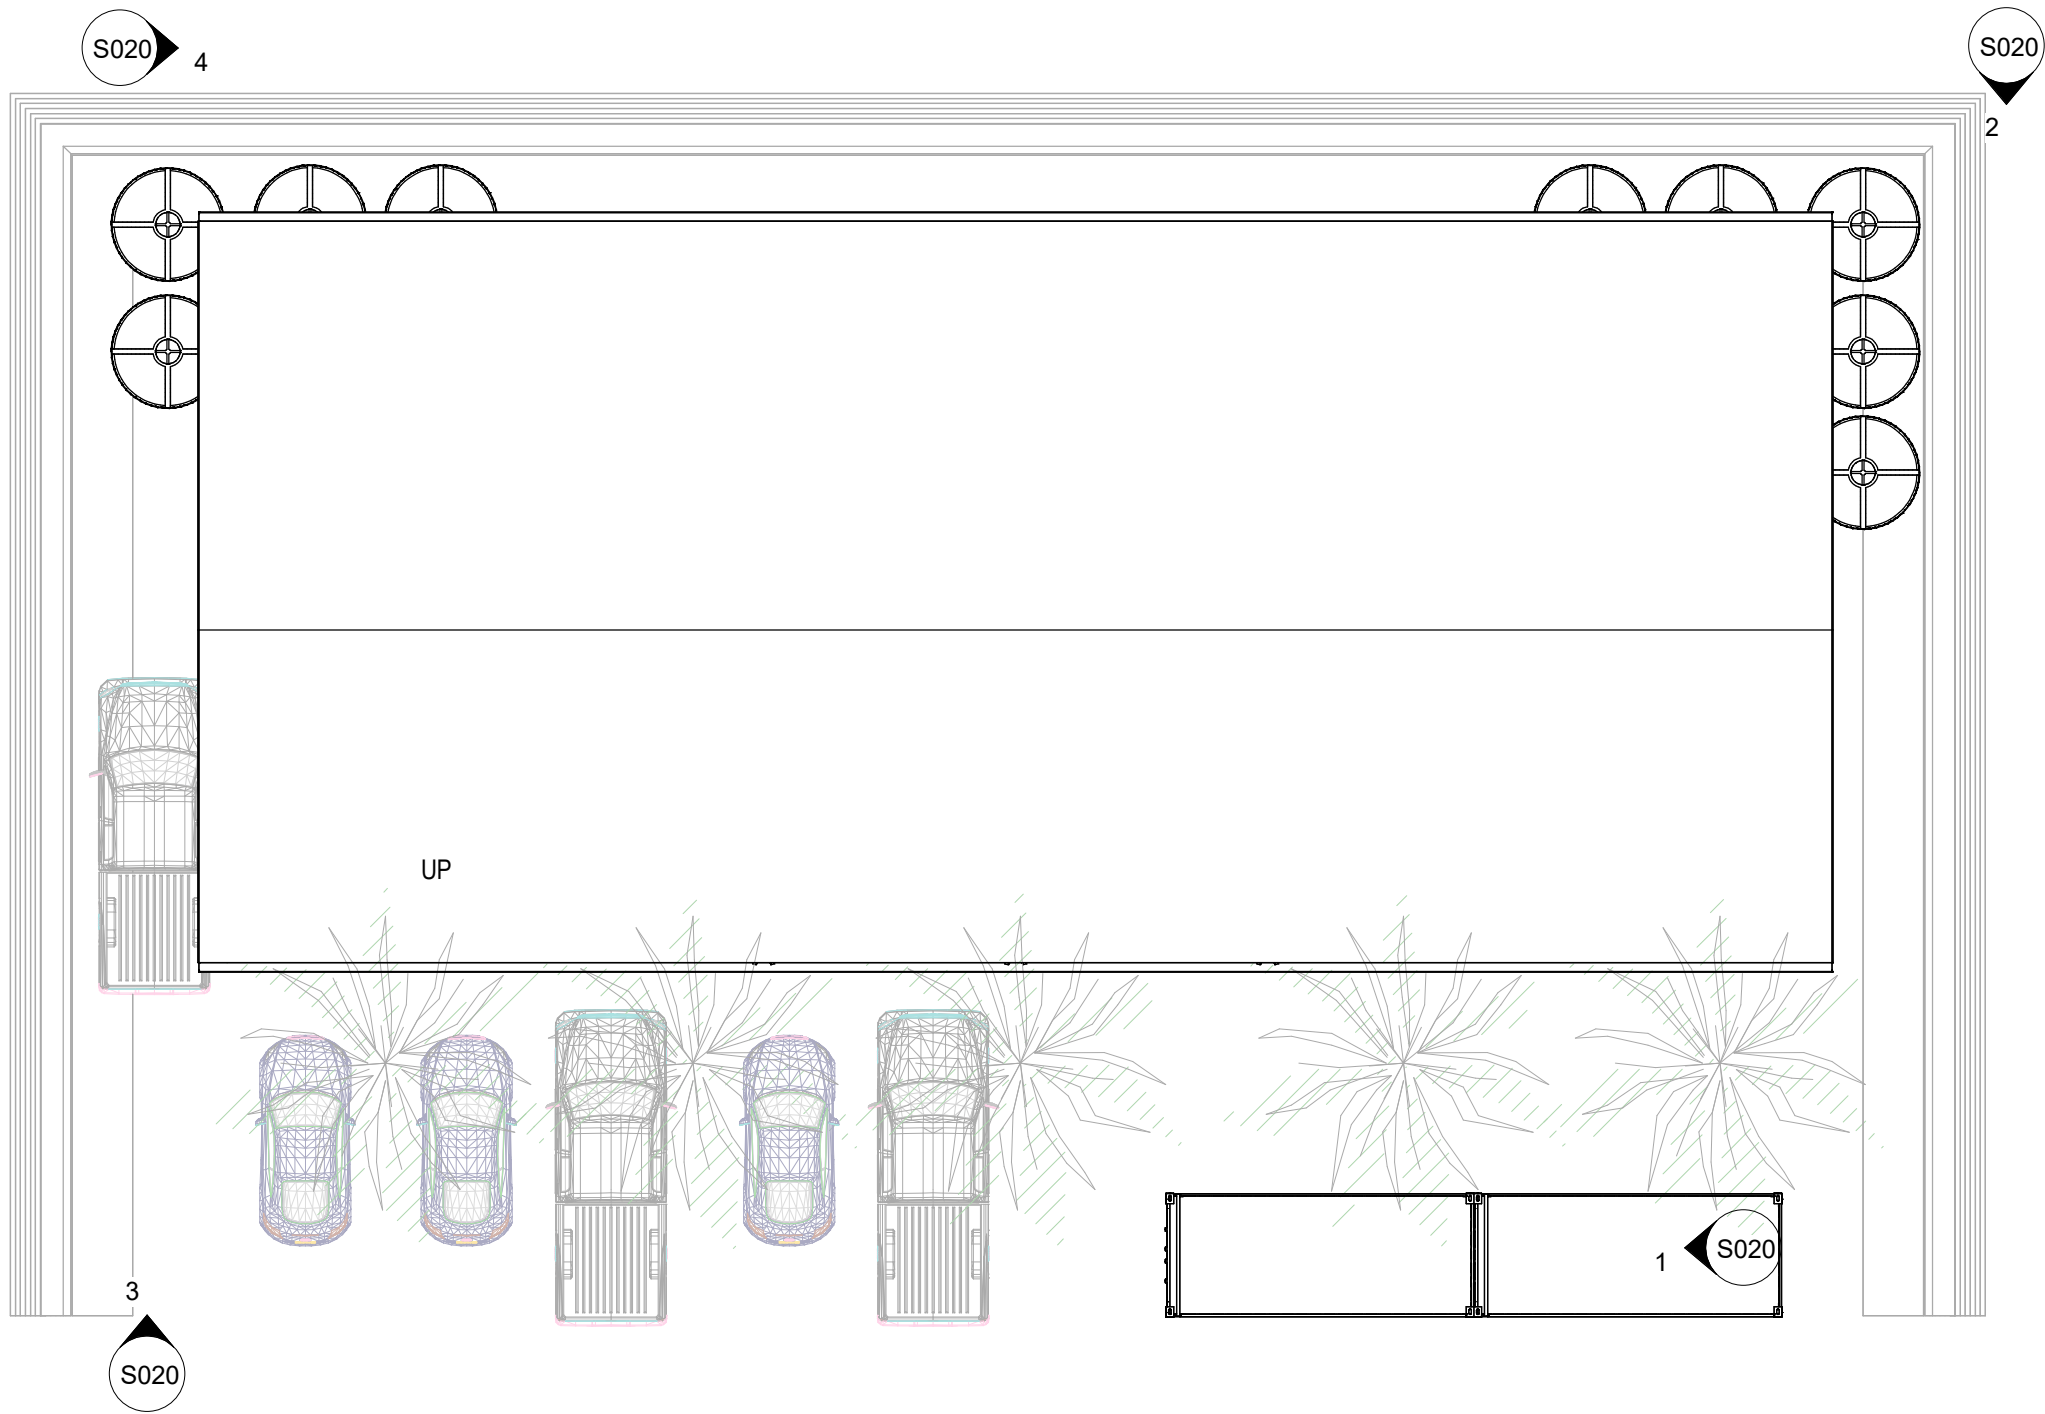

1 Level 2
Scale: 1 : 150



Bikenibeu Processing Plant

CLIENT: CPPL
PROJECT NO: GB2311

DWG TITLE:
LEVEL 2_PLAN


ARCHITECT: ttebau
ENGINEER: ttebau
DATE: 051225
SCALE: 1 : 150

DRAWING NUMBER: S07
ISSUE: Construction Design




COPYRIGHT
All rights reserved. This drawing set or any part of it shall not be reproduced or used in any manner whatsoever without the express written permission of DECons.


C:\Users\4090\OneDrive\Documents\work\2026\GB2311\1 - CPPL Bikenibeu Processing Plant\005 Drawing\03 Bikenibeu Processing Plant_280121.rvt

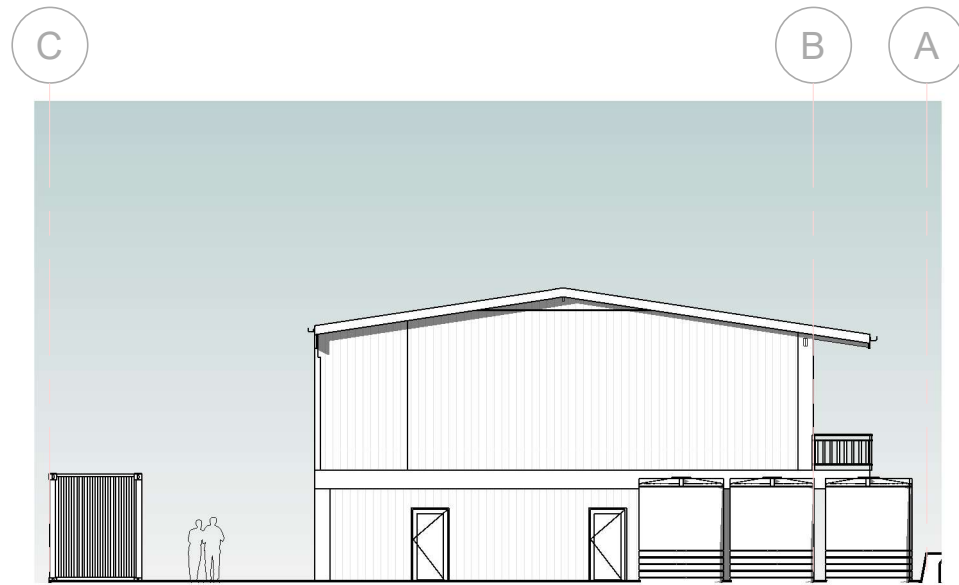


1 ELEVATION 1
Scale: 1 : 200

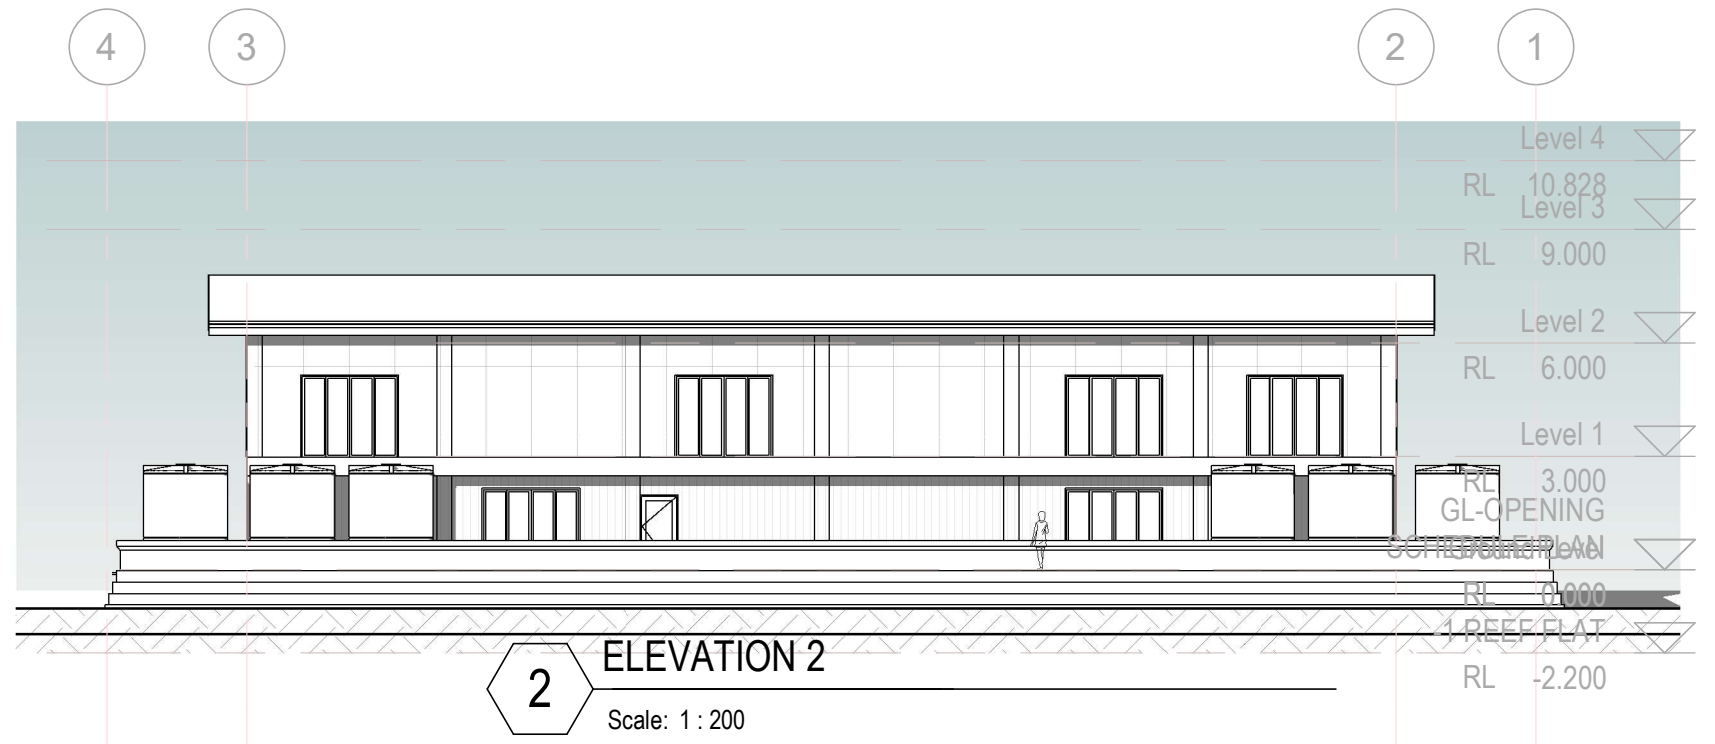

2 ELEVATION 2
Scale: 1 : 200

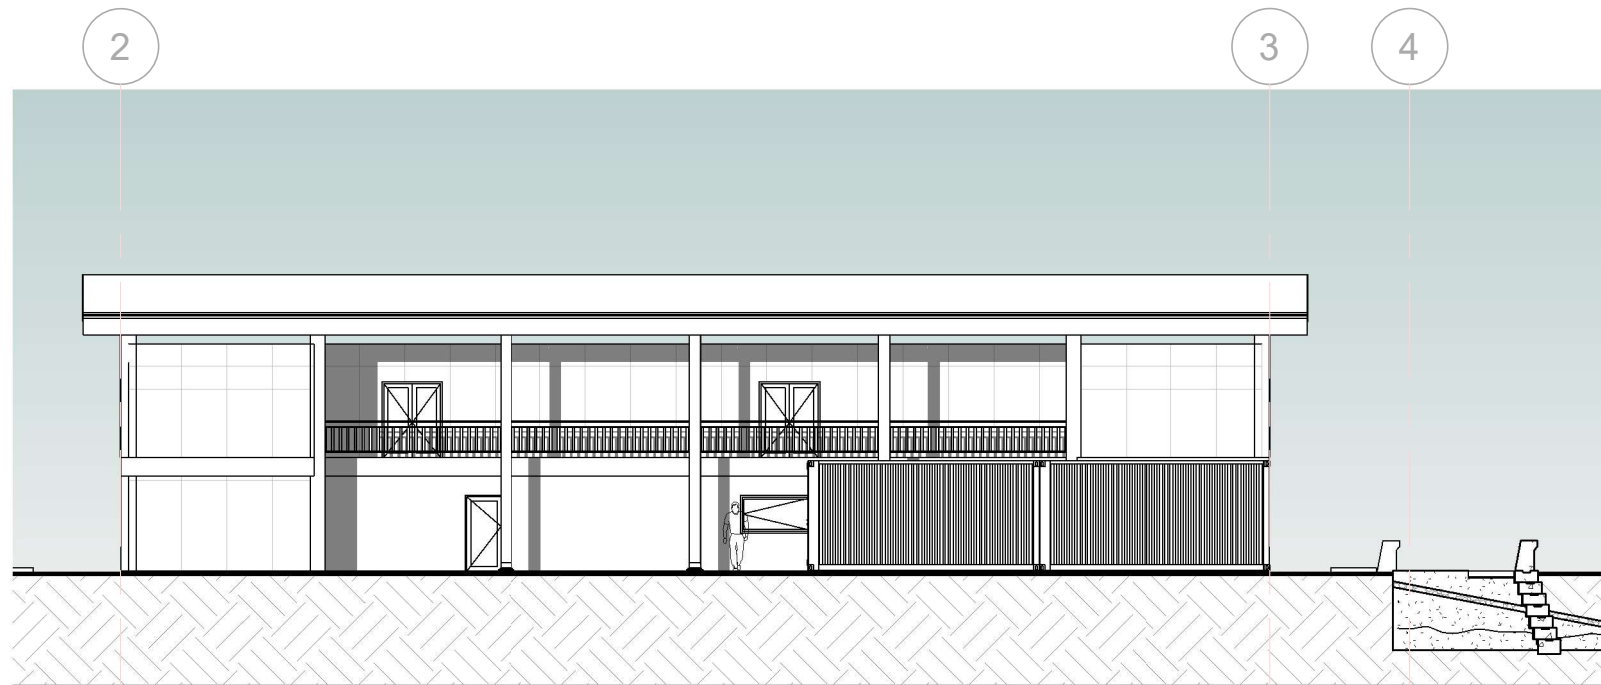

3 ELEVATION 3
Scale: 1 : 200

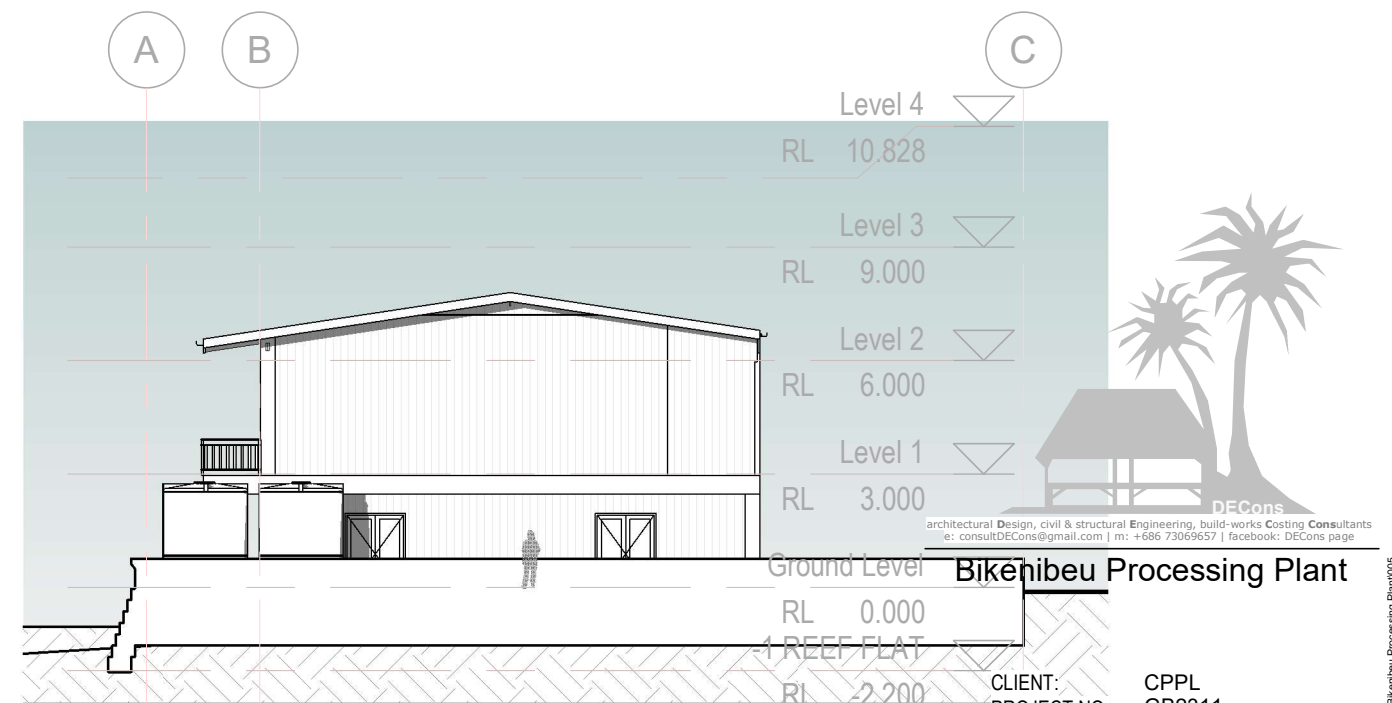

4 ELEVATION 4
Scale: 1 : 200

CLIENT: CPPL
PROJECT NO: GB2311


DWG TITLE:
ELEVATIONS

ARCHITECT: ttebau
ENGINEER: ttebau
DATE: 051225
SCALE: 1 : 200

DRAWING NUMBER: S020
ISSUE: Construction Design

COPYRIGHT
All rights reserved. This drawing set or any part of it shall not be reproduced or used in any manner whatsoever without the express written permission of DECons.

C:\Users\4090\OneDrive\Documents\work\2026\GB2311 - CPPL Bikenibeu Processing Plant\005 Drawing03 Elevation 1 to 4\GB2311 - CPPL Bikenibeu Processing Plant_260121.rvt

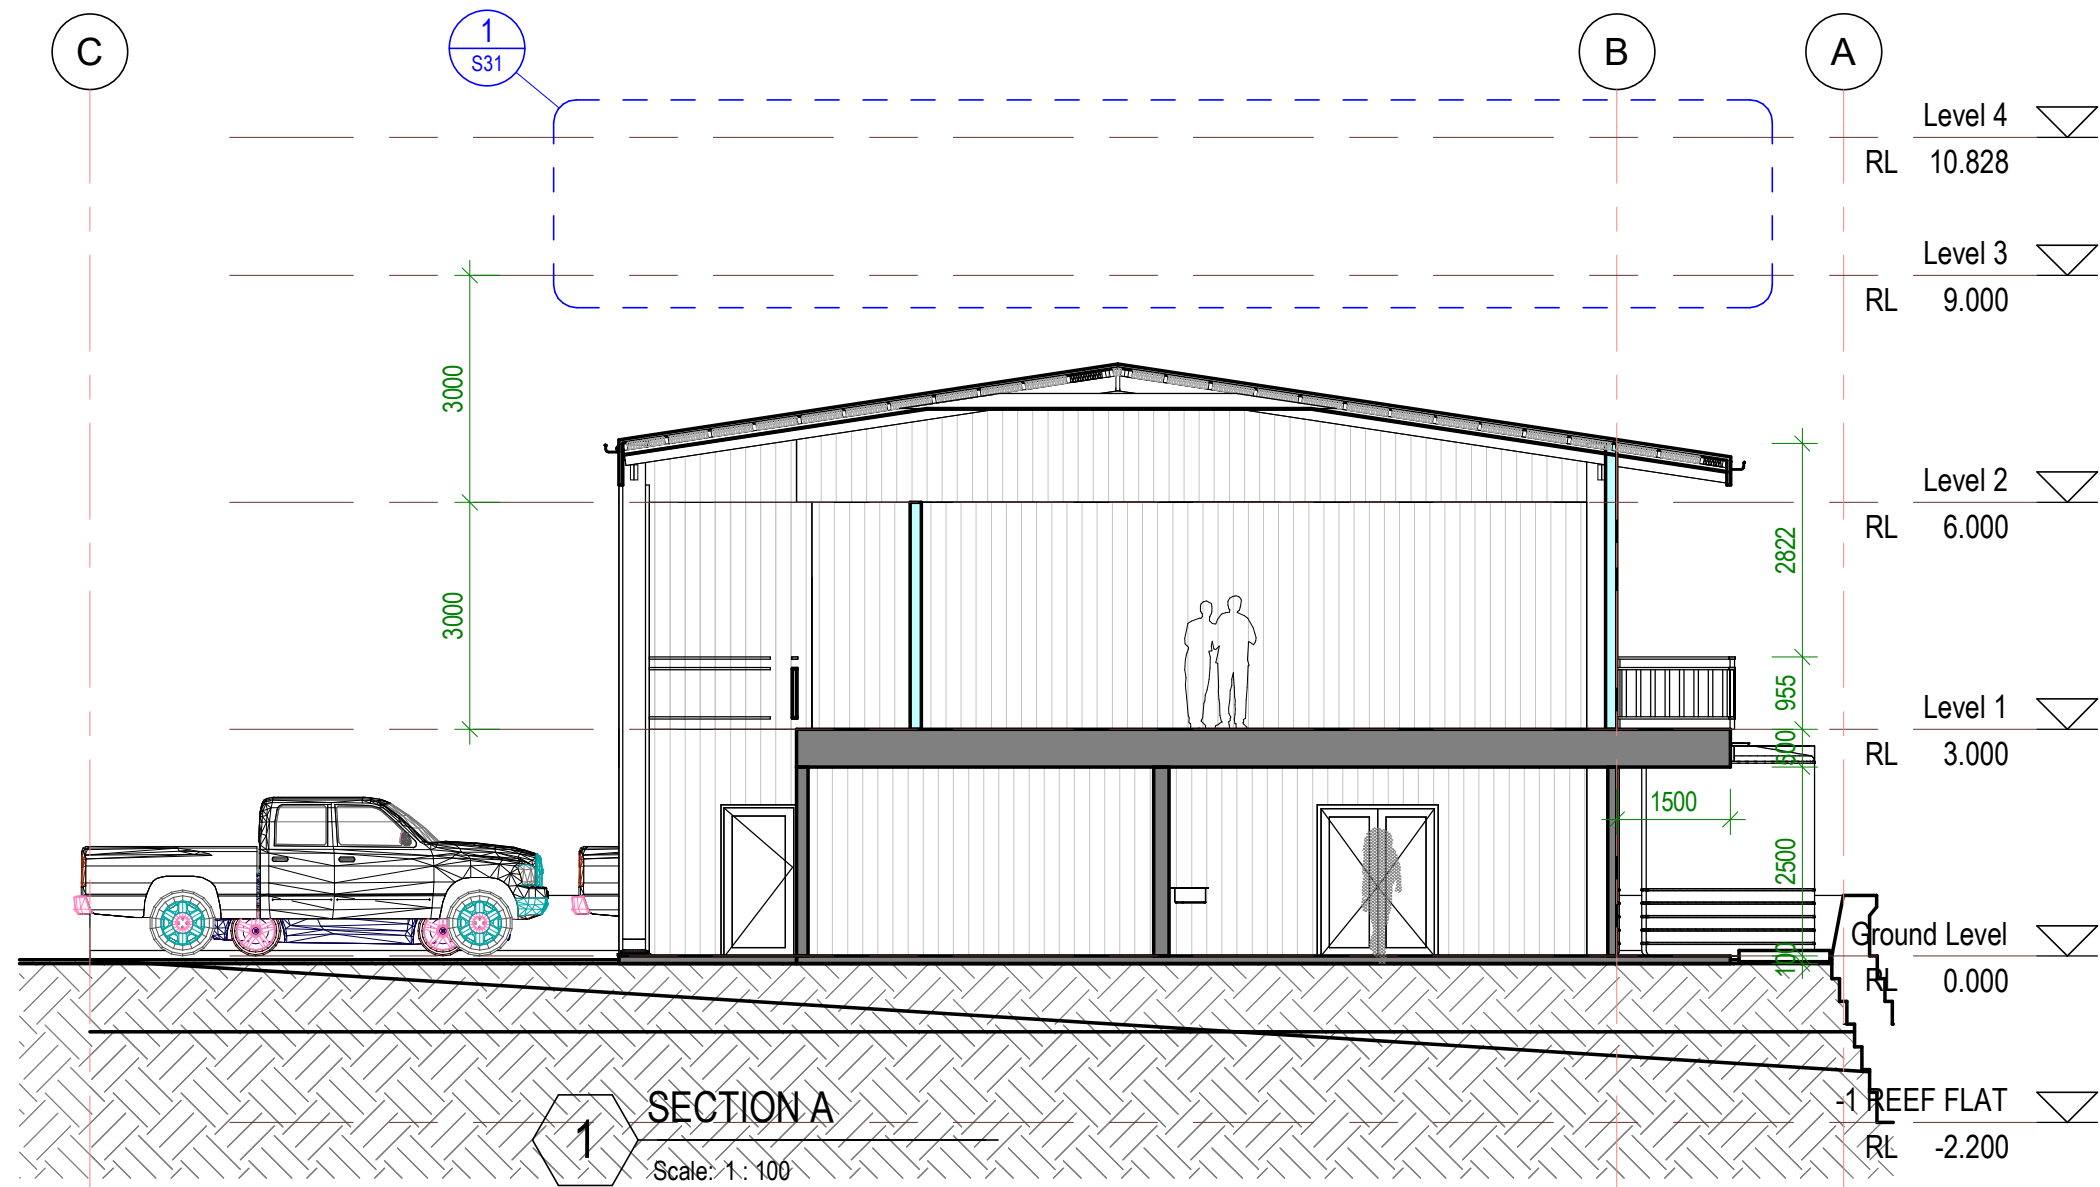

architectural Design, civil & structural Engineering, build-works Costing Consultants
e: consult@DECons.com | m: +686 73069657 | facebook: DECons page

Bikenibeu Processing Plant

CLIENT: CPPL
PROJECT NO: GB2311

DWG TITLE:
SECTIONS

ARCHITECT: ttebau
ENGINEER: ttebau
DATE: 051225
SCALE: 1: 100

DRAWING NUMBER: S030
ISSUE: Construction Design

COPYRIGHT
All rights reserved. This drawing set or any part of it shall not be reproduced or used in any manner whatsoever without the express written permission of DECons.

C:\Users\4090\OneDrive\Documents\work\2026\GB2311.1 - CPPL Bikenibeu Processing Plant\005 Drawing03 Bikenibeu Processing Plant_280121.rvt



Bikenibeu Processing Plant

CLIENT: CPPL
PROJECT NO: GB2311

DWG TITLE:
3D VIEWS

ARCHITECT: ttebau
ENGINEER: ttebau
DATE: 051225
SCALE:

DRAWING NUMBER: S41
ISSUE: Construction Design

COPYRIGHT
All rights reserved. This drawing set or any part of it shall not be reproduced or used in any manner whatsoever without the express written permission of DECons.

C:\Users\4090\OneDrive\Documents\Work\2026\GB2311 - CPPL Bikenibeu Processing Plant\005 Drawing\03 Select by ttebau\GB2311 - CPPL Bikenibeu Processing Plant_280121.rvt

21/01/2026 3:57:39 PM