
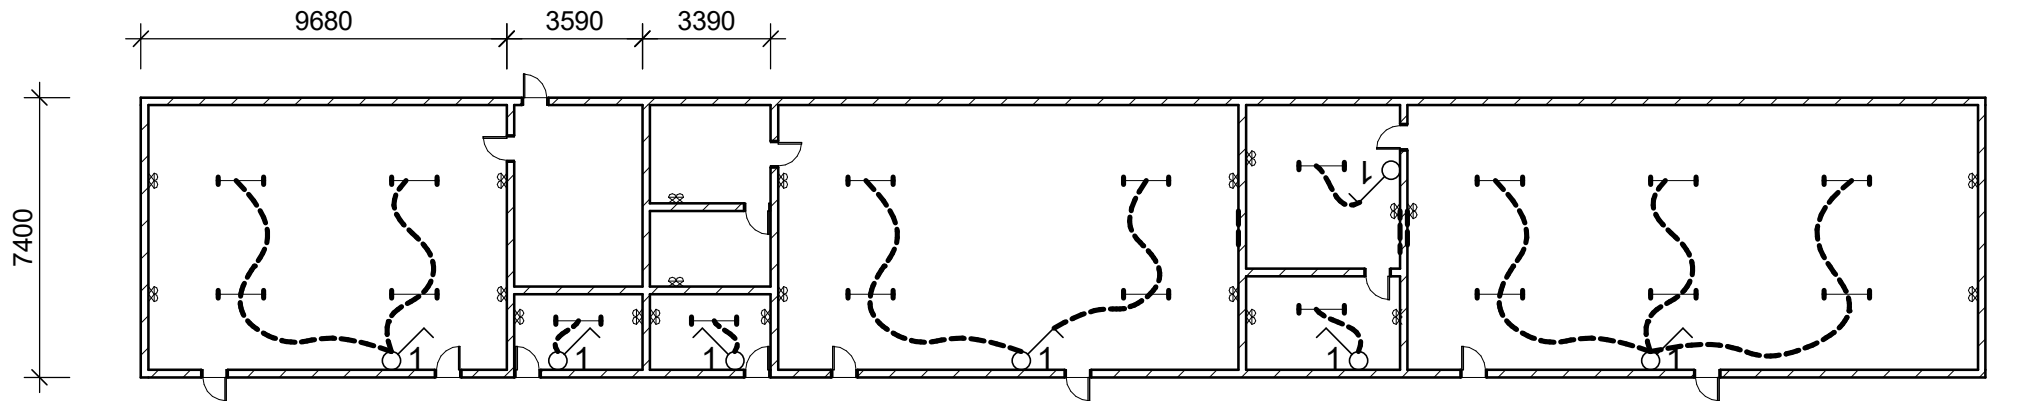


	Main switch board
	Double GPO
	Double GPO - with weatherproof cover/protection
	Selected compact ceiling light
	Light switch single, double, triple or quarible
	Earthing
	Wall mounted batten light
	Ceiling fan
	Cable wire
	4Ft LED Lights
	Fan switch double or single (depends on the no. noted)

1. WIRING ELECTRICAL SCHEMATIC PLANS SHALL BE INSTALLED BY A QUALIFIED AND LICENSED ELECTRICIAN/ENGINEER
2. WHERE APPLICABLE, USE ENERGY EFFICIENT APPLIANCES & LED LIGHTS
3. CABLE WIRE SIZES SHOULD BE:
 - 4 OR 6 sqmm FOR UNDERGROUND CABLES FROM PUB BOX TO HOUSEHOLD SWITCHBOARD
 - 2.5 sqmm CABLES CONNECTING SWITCH-BOARD TO GPOS
 - 2.5 sqmm CABLES CONNECTING SWITCH-BOARD TO SWITCH POINTS
 - 1.5 sqmm CABLES CONNECTING SWITCH-POINTS TO LIGHTS AND OTHER CEILING/WALL MOUNTED APPLIANCES

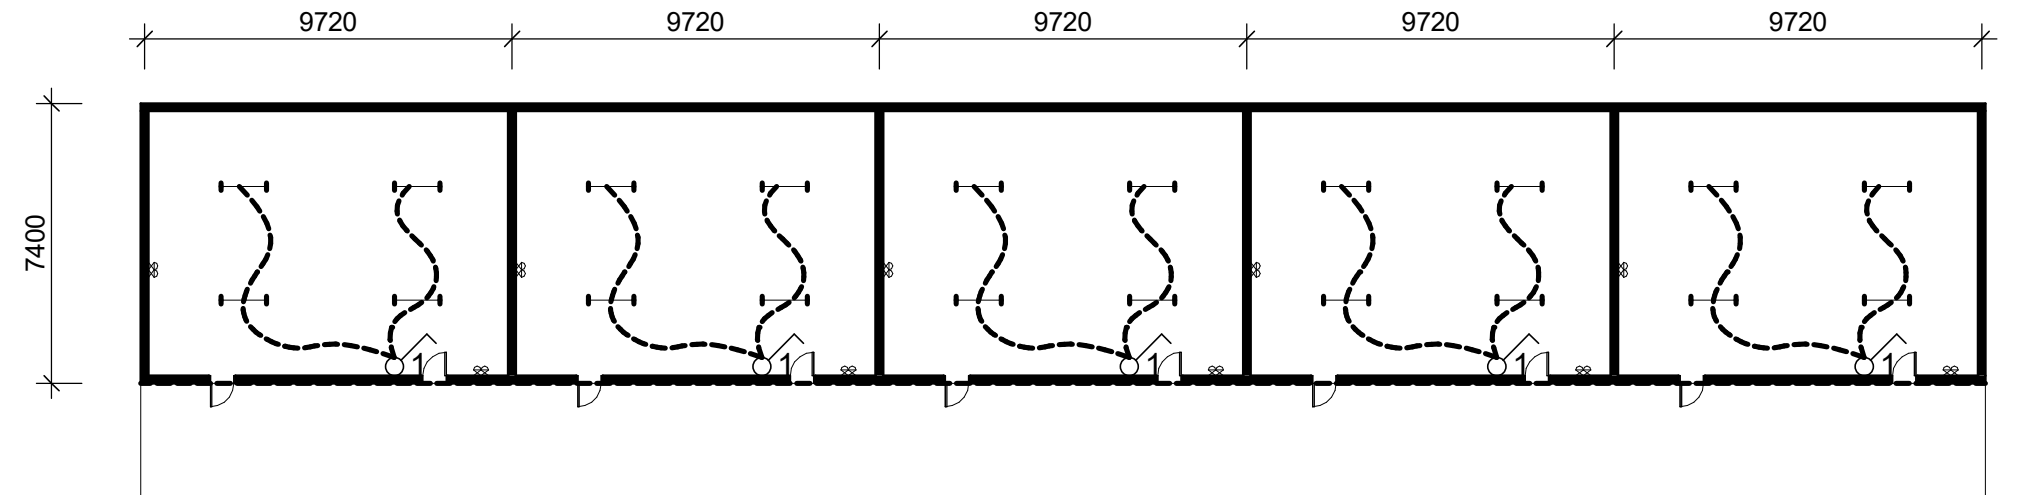

1 LEVEL GROUND
A50 S 1 : 200

TUC 1

DWG TITLE:

ELECTRICAL PLAN

DRAWN BY:
REVIEWED BY:
DATE:
SCALE:

DRAWING NUMBER: ISSUE:

A01

CONCEPT